

ANSI D 22" x 34"

Approved: R.HILLER


Checked: R.HILLER

Designer: R.HILLER

Drafter: HEATH ENGINEERING


Project Manager: R.HILLER

Last Plotted: 14.04.2023
Filename: I:\203701-DWG\REP\2037-PS-G-TBLK.dwg

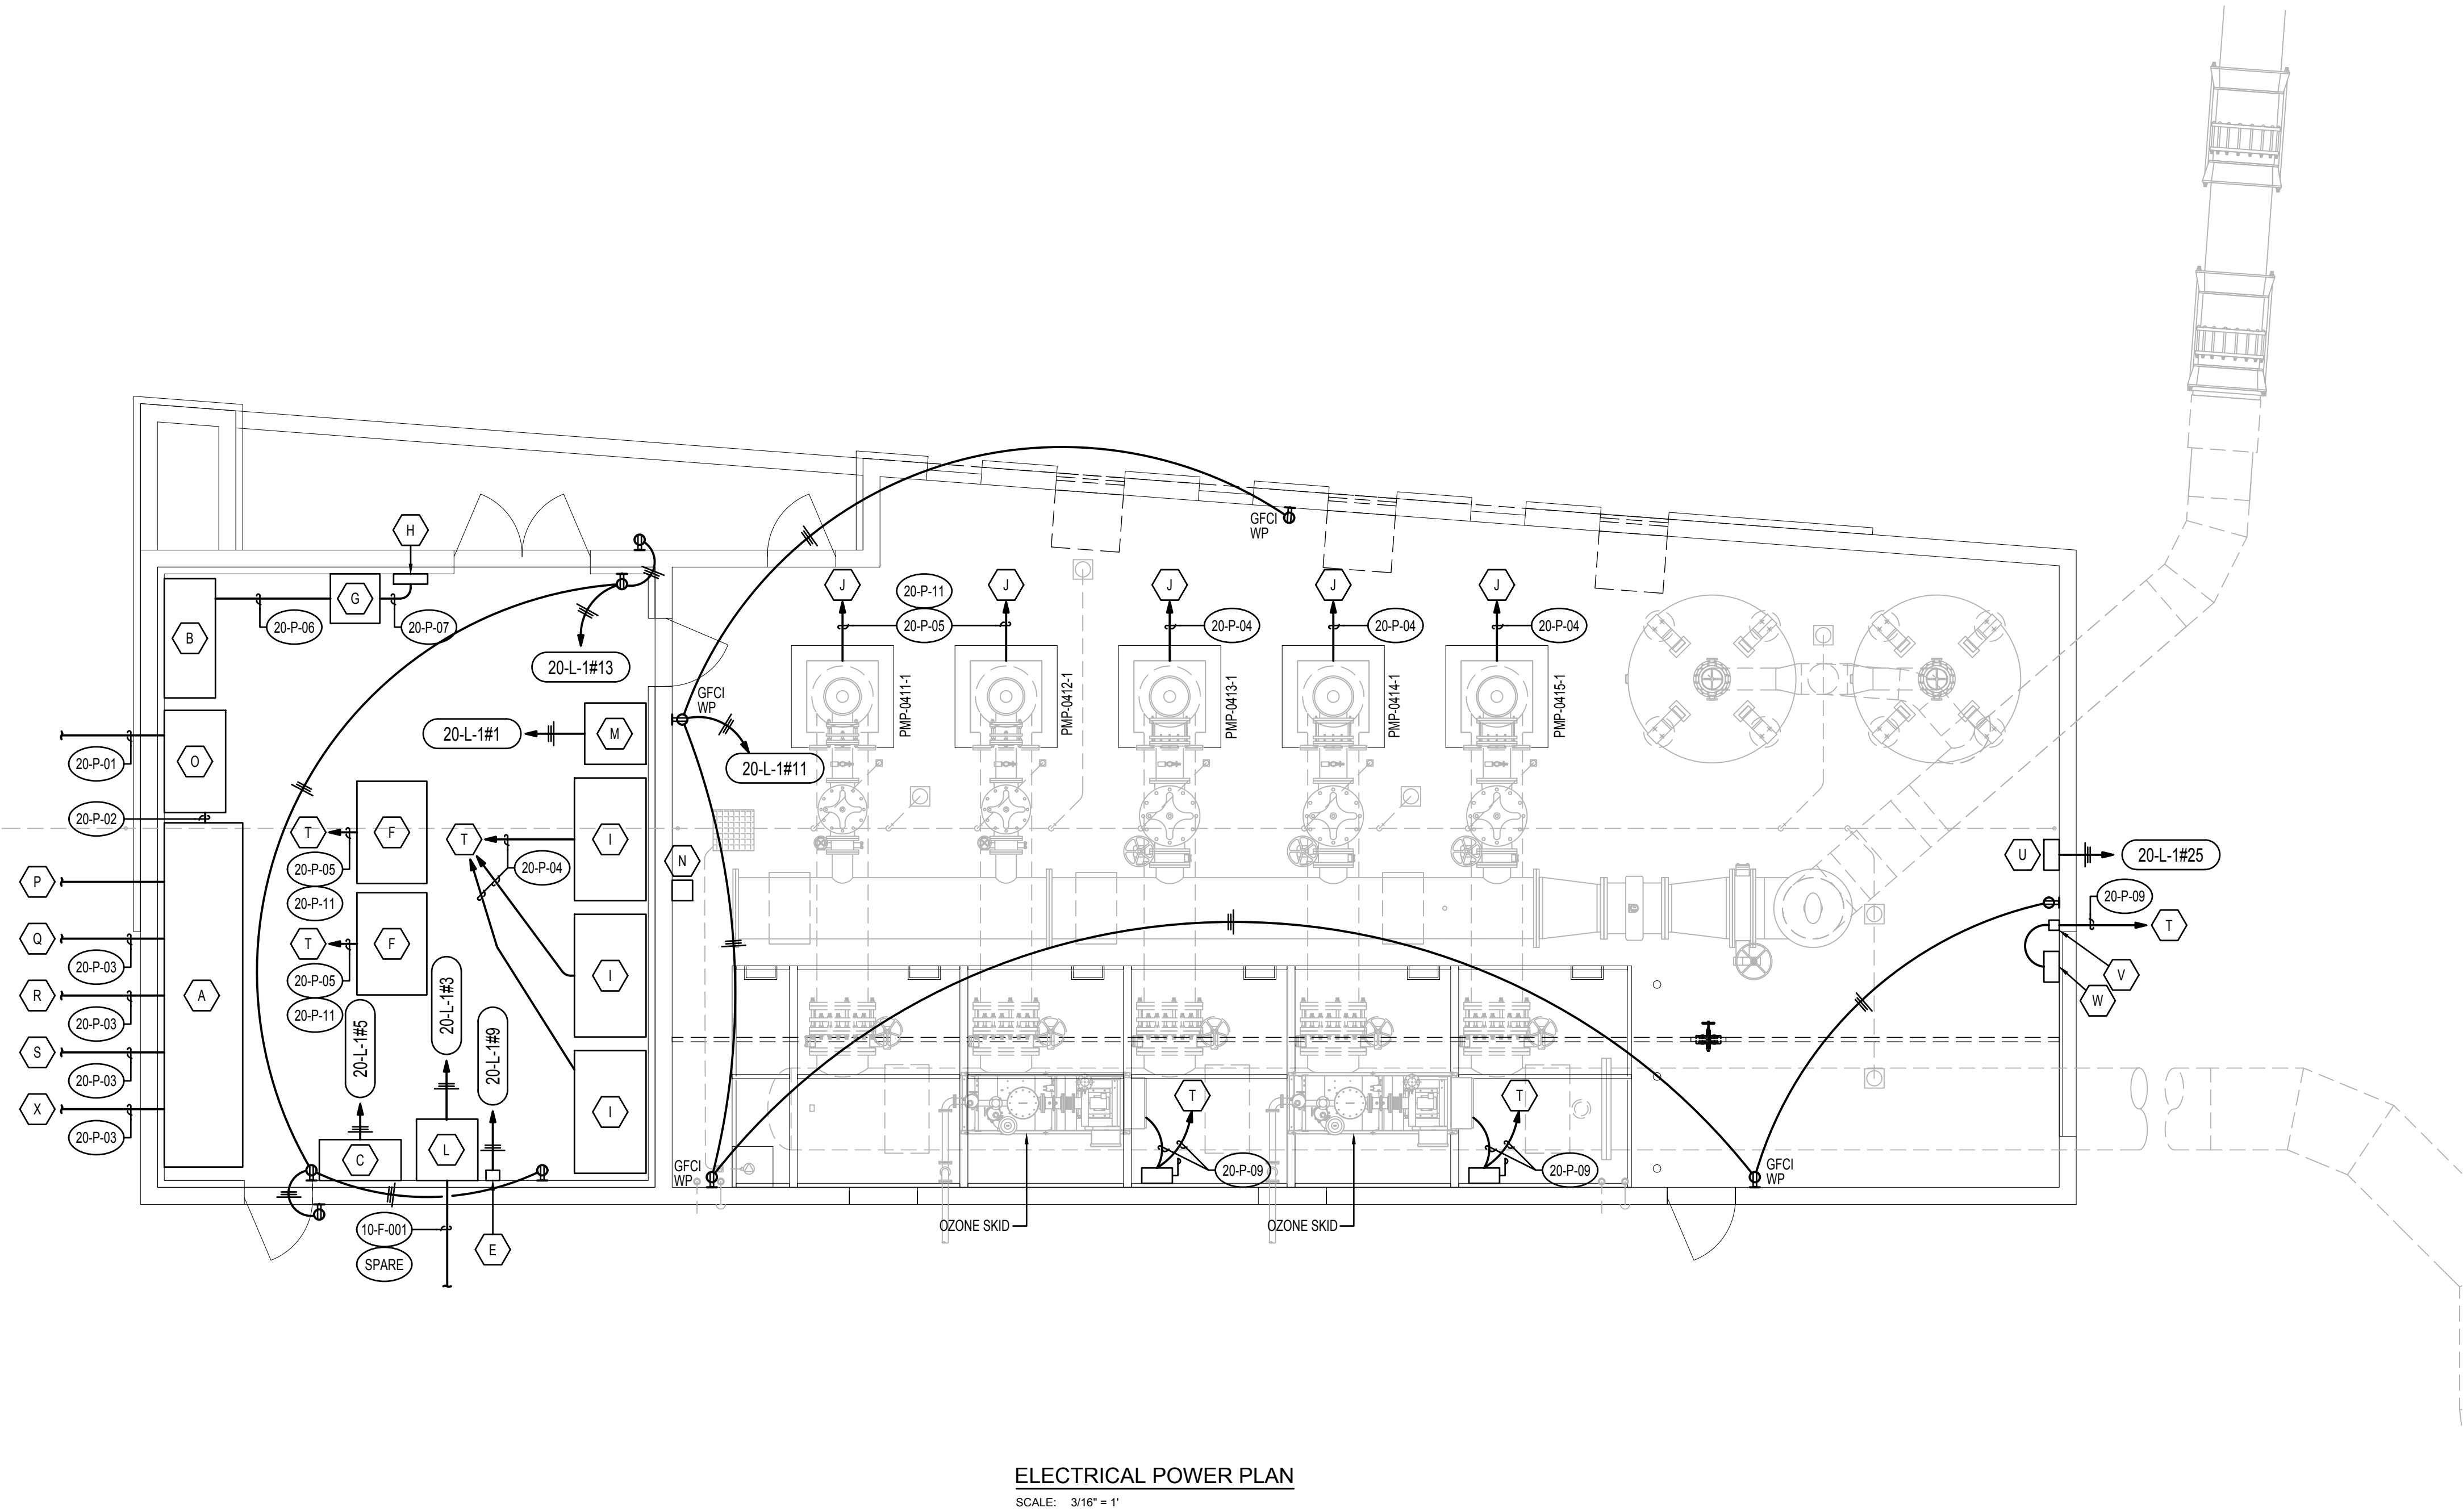

ELECTRICAL POWER PLAN
SCALE: 3/16" = 1'

 VERIFY SCALE
BAR IS ONE INCH ON ORIGINAL DRAWING



KEY NOTES

- A GENERATOR MAIN DISTRIBUTOR PANEL 01-GDP-1
- B MAIN DISTRIBUTION PANEL 20-MDP-1
- C PLC CABINET
- D NOT USED
- E FLOW TRANSMITTER
- F 300HP VFD CABINET WITH LOCKABLE DISCONNECT
- G 120 / 208V 3PH TRANSFORMER '20-X-1'
- H 120 / 208 PANEL '20-L-1'
- I 600HP VFD CABINET WITH LOCKABLE DISCONNECT
- J TO CORRESPONDING VFD CABINET
- K TO MDP. SEE SCHEDULE
- L NETWORK PANEL 'NET-0000-3'
- M SECURITY SYSTEM CONTROL PANEL 'NET-0000-4'
- N J-BOX WITH DUPLEX RJ45 RECEPTACLE FOR WIRELESS ACCESS POINT MOUNTED 10' AFF
- O AUTOMATIC TRANSFER SWITCH WITH BYPASS 20-ATS-1
- P TO FILTER BUILDING ATS
- Q TO GENERATOR 01-G-1
- R TO GENERATOR 01-G-2
- S TO GENERATOR 01-G-3
- T TO MDP. SEE SCHEDULE.
- U WATER QUALITY ANALYZER. AIT 0418-1A (CL). AIT 0418-1B (PH).
- V OVERHEAD DOOR CONTROLLER
- W OVERHEAD DOOR MOTOR
- X TO RESISTIVE LOAD. SEE SITE PLAN.



PROJECT

PROVO RIVER
WATER TREATMENT
PLANT


CLIENT

PROVO CITY
PUBLIC WORKS
1377 South 350 East
Provo, UT 84606
Tel: (801) 852-6700



CONSULTANTS

AECOM
756 East Winchester Street
Salt Lake City, UT 84107
Tel: (801) 904-4000 Fax: (801) 904-4100
http:// www.aecom.com
Hansen, Allen & Luce, Inc.
859 West South Jordan Pkwy. Ste 200
South Jordan, UT 84095
Tel: (801) 566-6599
http:// www.hansenallenluce.com

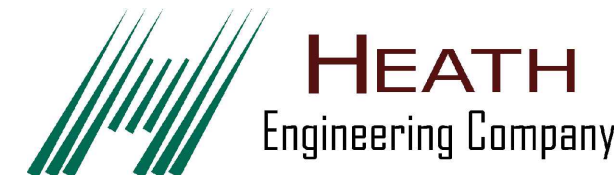

REGISTRATION



ISSUE/REVISION

I/R	DATE	DESCRIPTION
B	2023-04-07	ISSUED FOR BID
A	2023-01-20	ISSUED FOR 90%

PROJECT NUMBER


AECOM Project No. - 60670884
HAL Project No. - 035.15.420

SHEET TITLE

CLEARWELL AND
PUMP STATION
ELECTRICAL
PUMP STATION POWER
PLAN

DRAWING NUMBER

20-E101

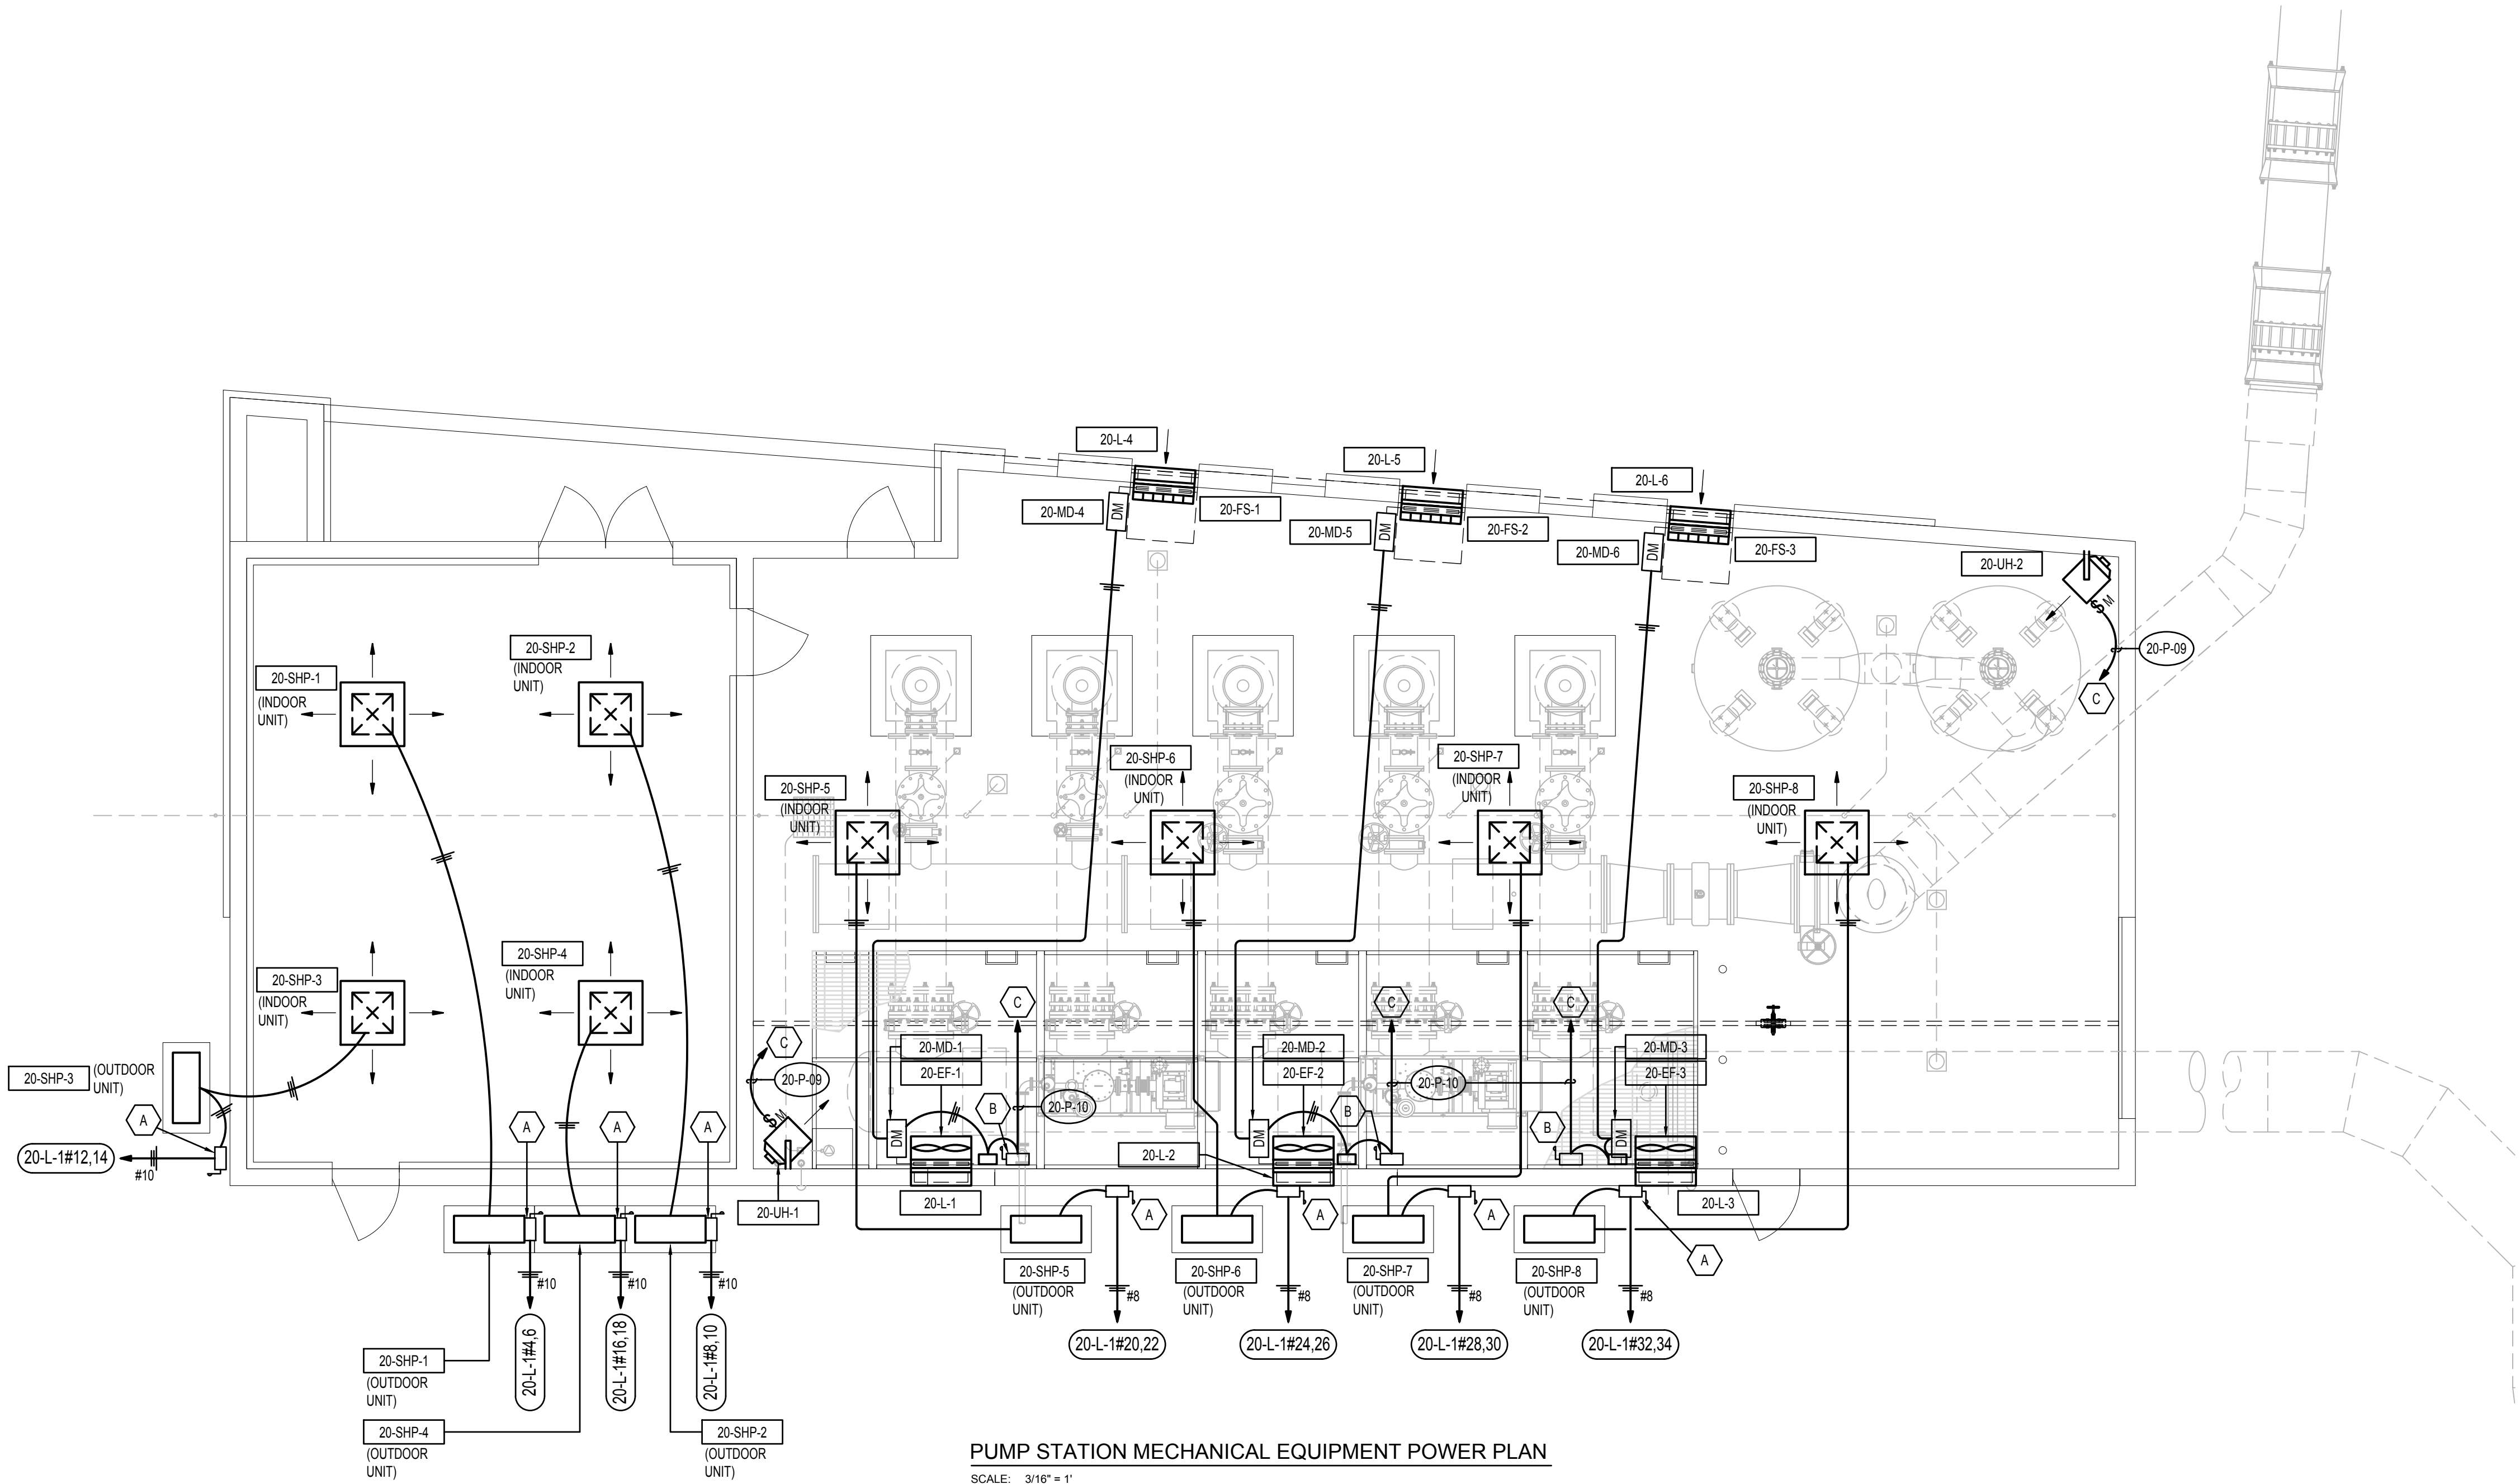

VERIFY SCALE
BAR IS ONE INCH ON ORIGINAL DRAWING



KEY NOTES

- A DISCONNECT 30A 2-POLE 240V NEMA 3R HEAVY DUTY. FUSE PER NAMEPLATE.
- B DISCONNECT 20A 3-POLE 600V NEMA 12 HEAVY DUTY. FUSE PER NAMEPLATE.
- C TO '20-MDP-1'



PROJECT

PROVO RIVER
WATER TREATMENT
PLANT


CLIENT

PROVO CITY
PUBLIC WORKS
1377 South 350 East
Provo, UT 84606
Tel: (801) 852-6700



CONSULTANTS

AECOM
756 East Winchester Street
Salt Lake City, UT 84107
Tel: (801) 904-4000 Fax: (801) 904-4100
http:// www.aecom.com
Hansen, Allen & Luce, Inc.
859 West South Jordan Pkwy. Ste 200
South Jordan, UT 84095
Tel: (801) 566-6599
http:// www.hansenallenluce.com

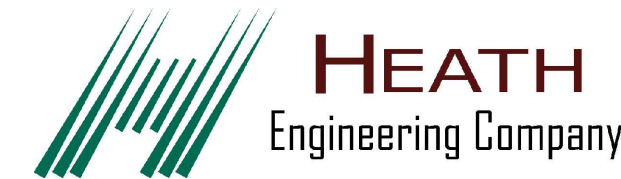

REGISTRATION



ISSUE/REVISION

I/R	DATE	DESCRIPTION
B	2023-04-07	ISSUED FOR BID
A	2023-01-20	ISSUED FOR 90%

PROJECT NUMBER

AECOM Project No. - 60670884
HAL Project No. - 035.15.420


SHEET TITLE

CLEARWELL AND
PUMP STATION
ELECTRICAL
PUMP STATION MECH
EQUIP POWER PLAN

DRAWING NUMBER


20-E102

ANSI D 22" x 34" Approved: R.HILLYER Checked: R.HILLYER Designer: R.HILLYER Drafter: HEATH ENGINEERING Project Manager: R.HILLYER Last Plotted: 14.04.2023 Filename: I:\203701-DWG\REP\2037-PS-G-TBLK.dwg

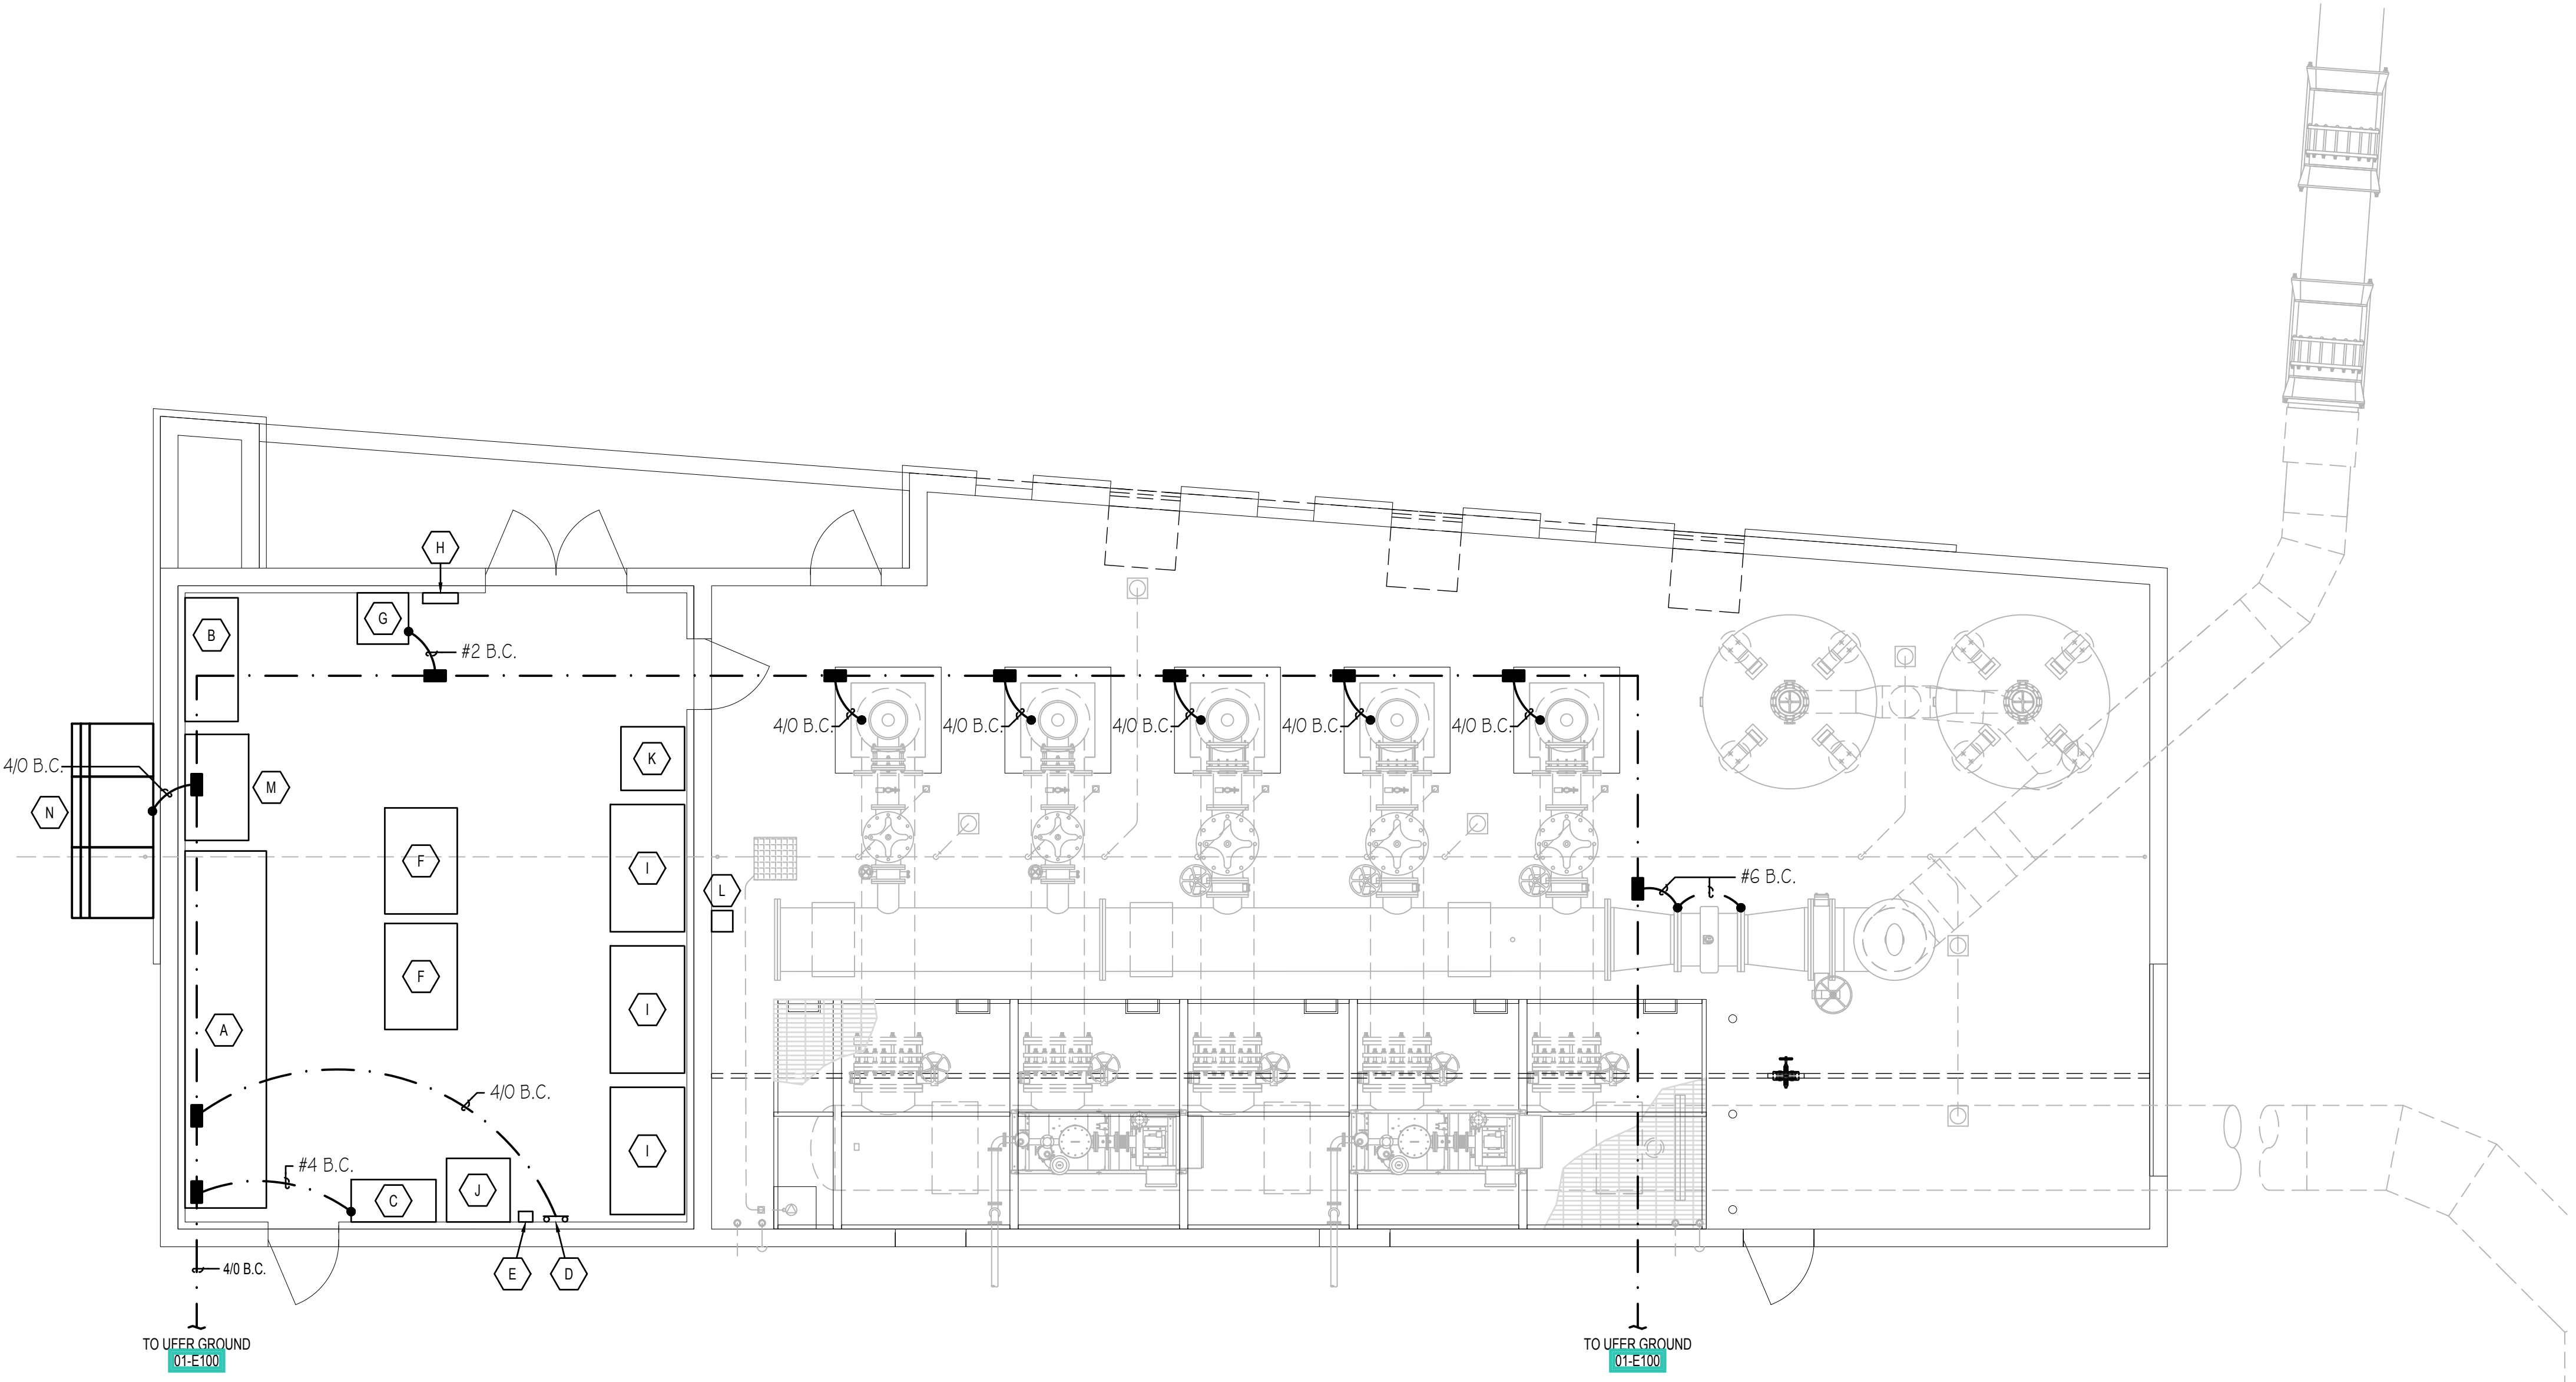

ELECTRICAL GROUNDING PLAN
SCALE: 3/16" = 1'

 VERIFY SCALE
BAR IS ONE INCH ON ORIGINAL DRAWING



KEY NOTES

- A GENERATOR MAIN DISTRIBUTOR PANEL 01-GDP-1
- B MAIN DISTRIBUTION PANEL 20-MDP-1
- C PLC CABINET
- D GROUND BUS. SEE 03-E701 DETAIL E013.
- E FLOW TRANSMITTER
- F 300HP VFD CABINET
- G 120 / 208V 3PH TRANSFORMER '20-X-1'
- H 120 / 208 PANEL '20-L-1'
- I 600HP VFD CABINET
- J NETWORK PANEL 'NET-0000-3'
- K SECURITY SYSTEM CONTROL PANEL 'NET-0000-4'
- L J-BOX WITH DUPLEX RJ45 RECEPTACLE FOR WIRELESS ACCESS POINT MOUNTED 10" AFF
- M AUTOMATIC TRANSFER SWITCH WITH BYPASS 20-ATS-1
- N METER AND DISCONNECT



PROJECT

PROVO RIVER
WATER TREATMENT
PLANT


CLIENT

PROVO CITY
PUBLIC WORKS
1377 South 350 East
Provo, UT 84606
Tel: (801) 852-6700



CONSULTANTS

AECOM
756 East Winchester Street
Salt Lake City, UT 84107
Tel: (801) 904-4000 Fax: (801) 904-4100
http:// www.aecom.com
Hansen, Allen & Luce, Inc.
859 West South Jordan Pkwy, Ste 200
South Jordan, UT 84095
Tel: (801) 566-6599
http:// www.hansenallenluce.com

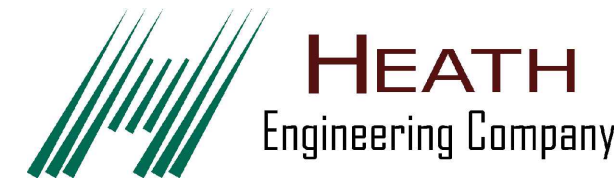

REGISTRATION



ISSUE/REVISION

I/R	DATE	DESCRIPTION
B	2023-04-07	ISSUED FOR BID
A	2023-01-20	ISSUED FOR 90%

PROJECT NUMBER

AECOM Project No. - 60670884
HAL Project No. - 035.15.420


SHEET TITLE

CLEARWELL AND
PUMP STATION
ELECTRICAL
PUMP STATION
GROUNDING PLAN

DRAWING NUMBER

20-E103

ANSI D 22" x 34" Approved: R.HILLYER Checked: R.HILLYER Designer: R.HILLYER Drafter: HEATH ENGINEERING Project Manager: R.HILLYER Last Plotted: 14.04.2023 Filename: I:\203701-DWG\REF\2037-PS-G-TBLK.dwg

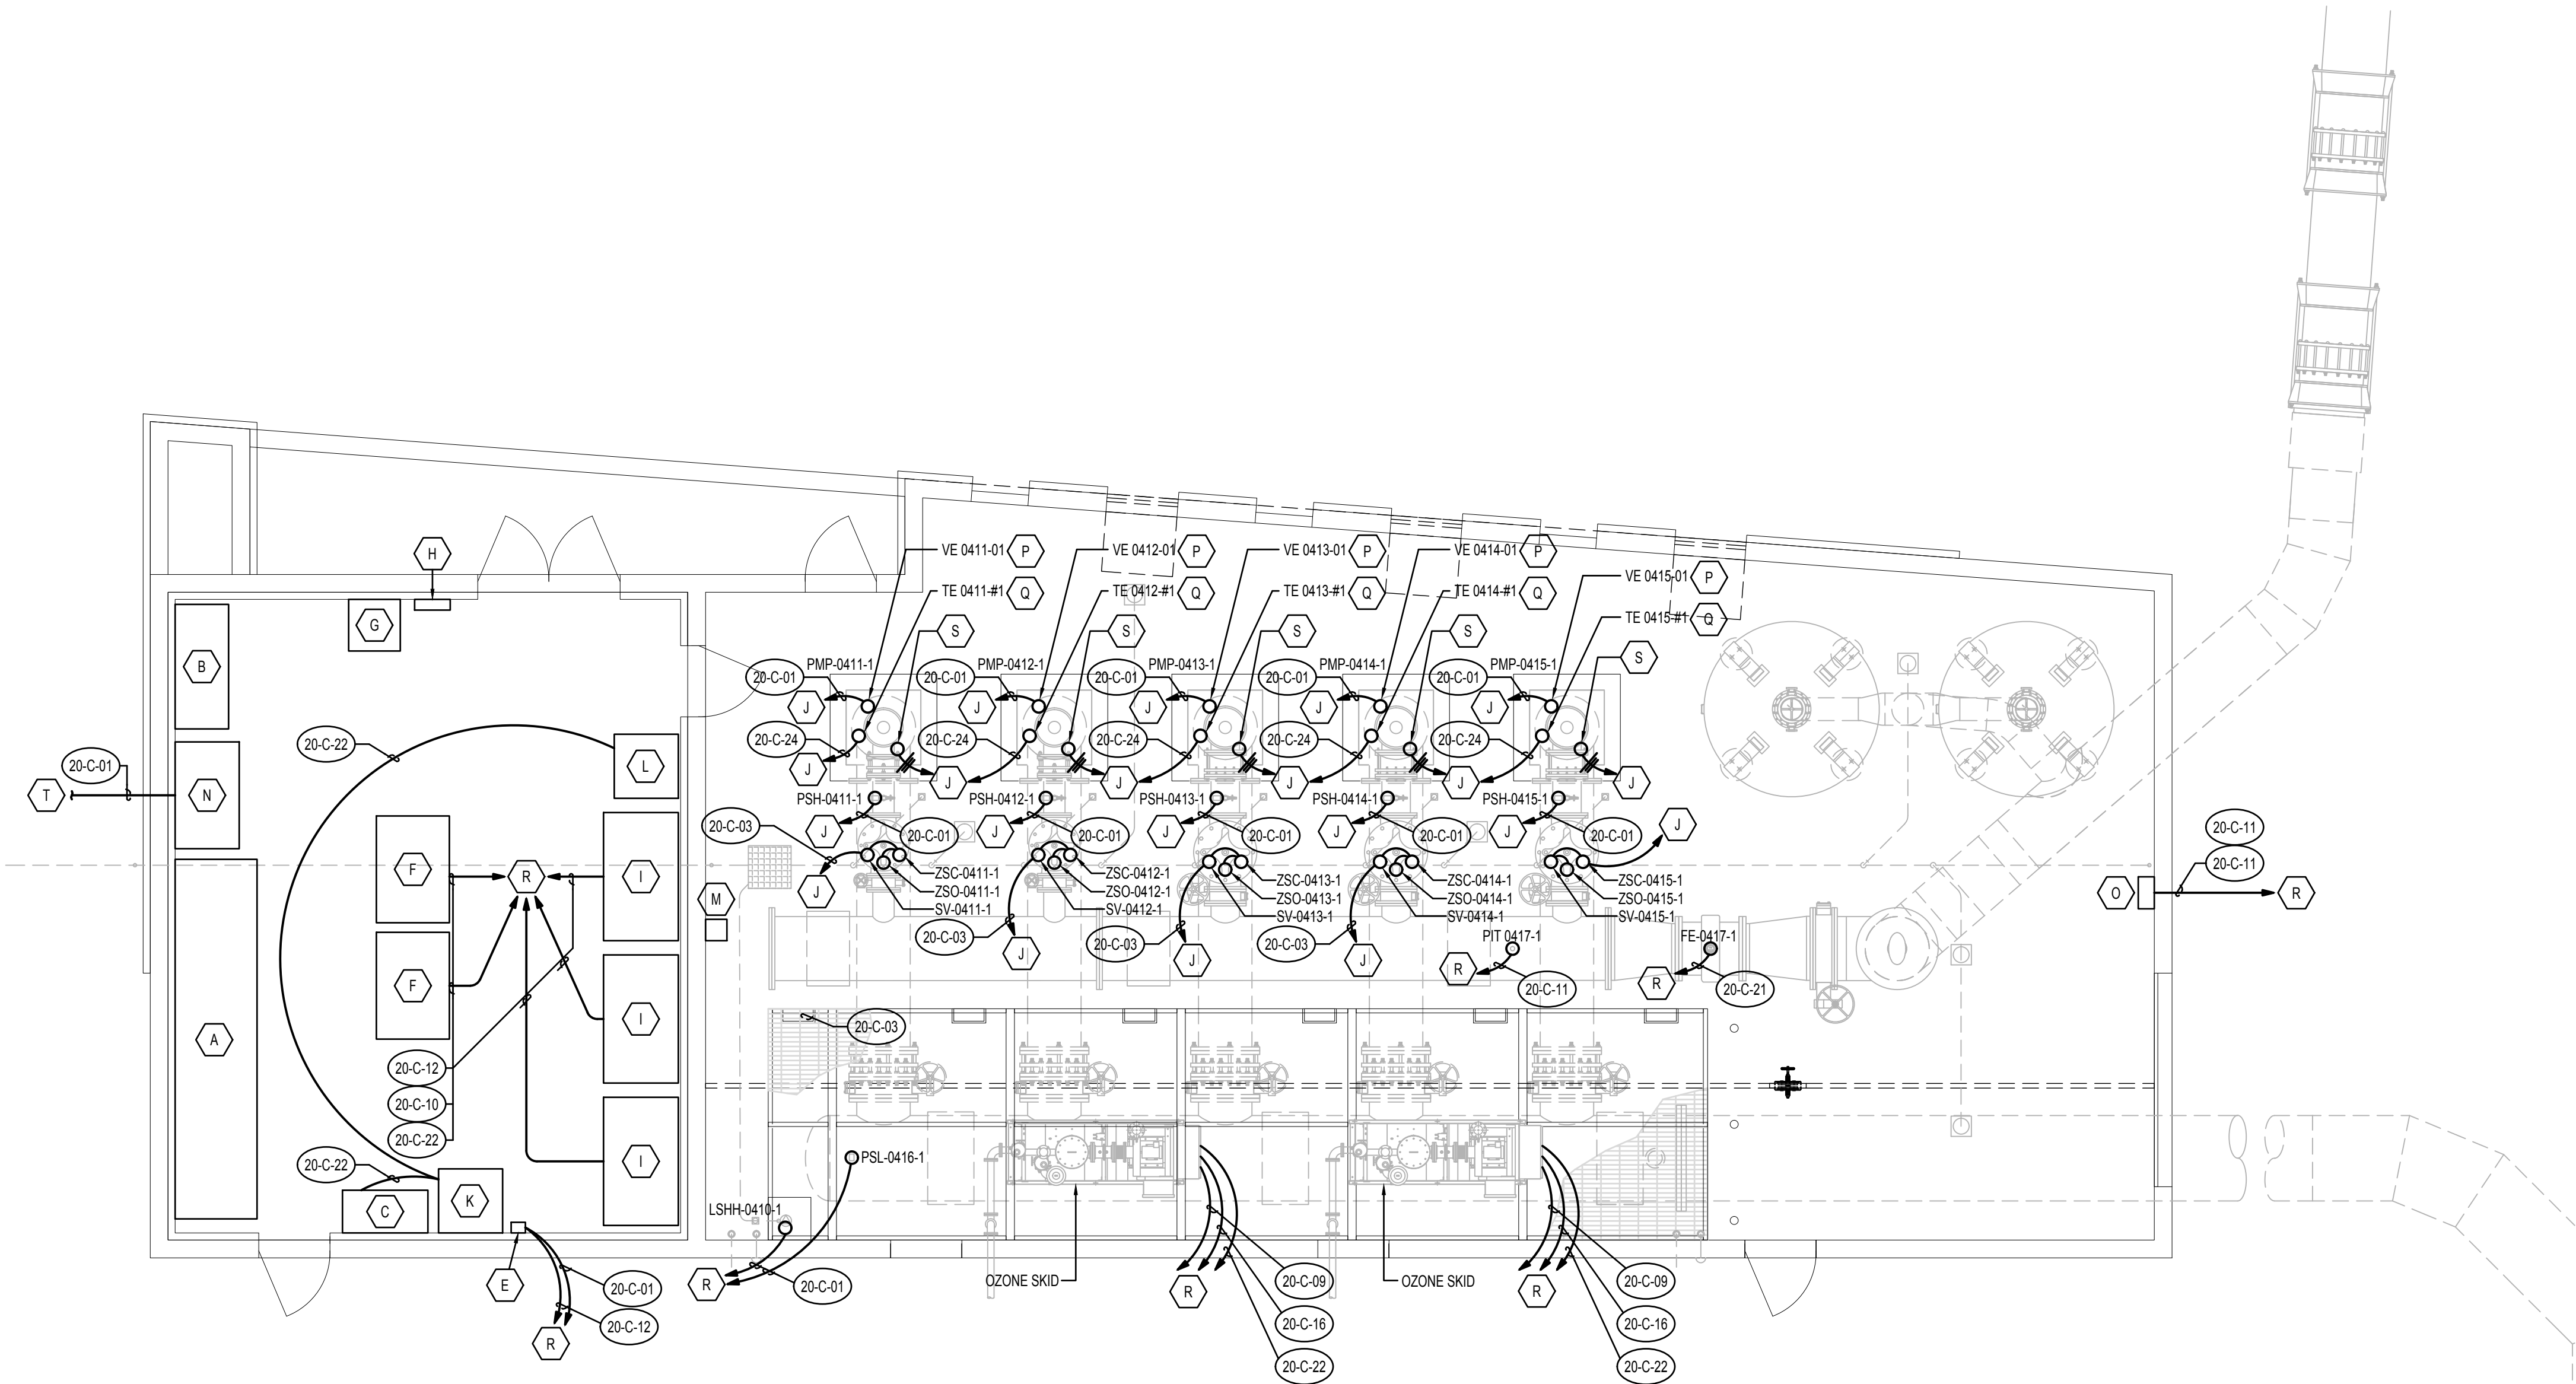

ELECTRICAL CONTROLS PLAN
SCALE: 3/16" = 1'

VERIFY SCALE
BAR IS ONE INCH ON ORIGINAL DRAWING



KEY NOTES

- A GENERATOR MAIN DISTRIBUTOR PANEL 01-GDP-1
- B MAIN DISTRIBUTION PANEL 20-MDP-1
- C PLC CABINET
- D NOT USED
- E FLOW TRANSMITTER FIT-0417-1 WITH FSL-0417-1 SWITCH
- F 300HP VFD CABINET
- G 120 / 208V 3PH TRANSFORMER '20-X-1'
- H 120 / 208 PANEL '20-L-1'
- I 600HP VFD CABINET
- J TO CORRESPONDING VFD CABINET
- K NETWORK PANEL 'NET-0000-3'
- L SECURITY SYSTEM CONTROL PANEL 'NET-0000-4'
- M J-BOX WITH DUPLEX RJ45 RECEPTACLE FOR WIRELESS ACCESS POINT MOUNTED 10" AFF
- N AUTOMATIC TRANSFER SWITCH WITH BYPASS 20-ATS-1
- O WATER QUALITY ANALYZER. AIT 0418-1A (CL). AIT 0418-1B (pH).
- P VIBRATION SWITCH
- Q RTD'S 6 WINDING AND ONE PER BEARING
- R TO PLC
- S WINDING HEATER
- T TO FIRST GENERATOR CONTROLLER



PROJECT

PROVO RIVER
WATER TREATMENT
PLANT


CLIENT

PROVO CITY
PUBLIC WORKS
1377 South 350 East
Provo, UT 84606
Tel: (801) 852-6700



CONSULTANTS

AECOM
756 East Winchester Street
Salt Lake City, UT 84107
Tel: (801) 904-4000 Fax: (801) 904-4100
http://www.aecom.com
Hansen, Allen & Luce, Inc.
859 West South Jordan Pkwy, Ste 200
South Jordan, UT 84095
Tel: (801) 566-6599
http://www.hansenallenluce.com

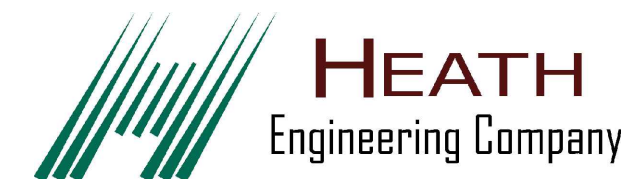

REGISTRATION



ISSUE/REVISION

I/R	DATE	DESCRIPTION
B	2023-04-07	ISSUED FOR BID
A	2023-01-20	ISSUED FOR 90%

PROJECT NUMBER


AECOM Project No. - 60670884
HAL Project No. - 035.15.420

SHEET TITLE

CLEARWELL AND
PUMP STATION
ELECTRICAL
PUMP STATION
CONTROLS PLAN

DRAWING NUMBER


20-E104

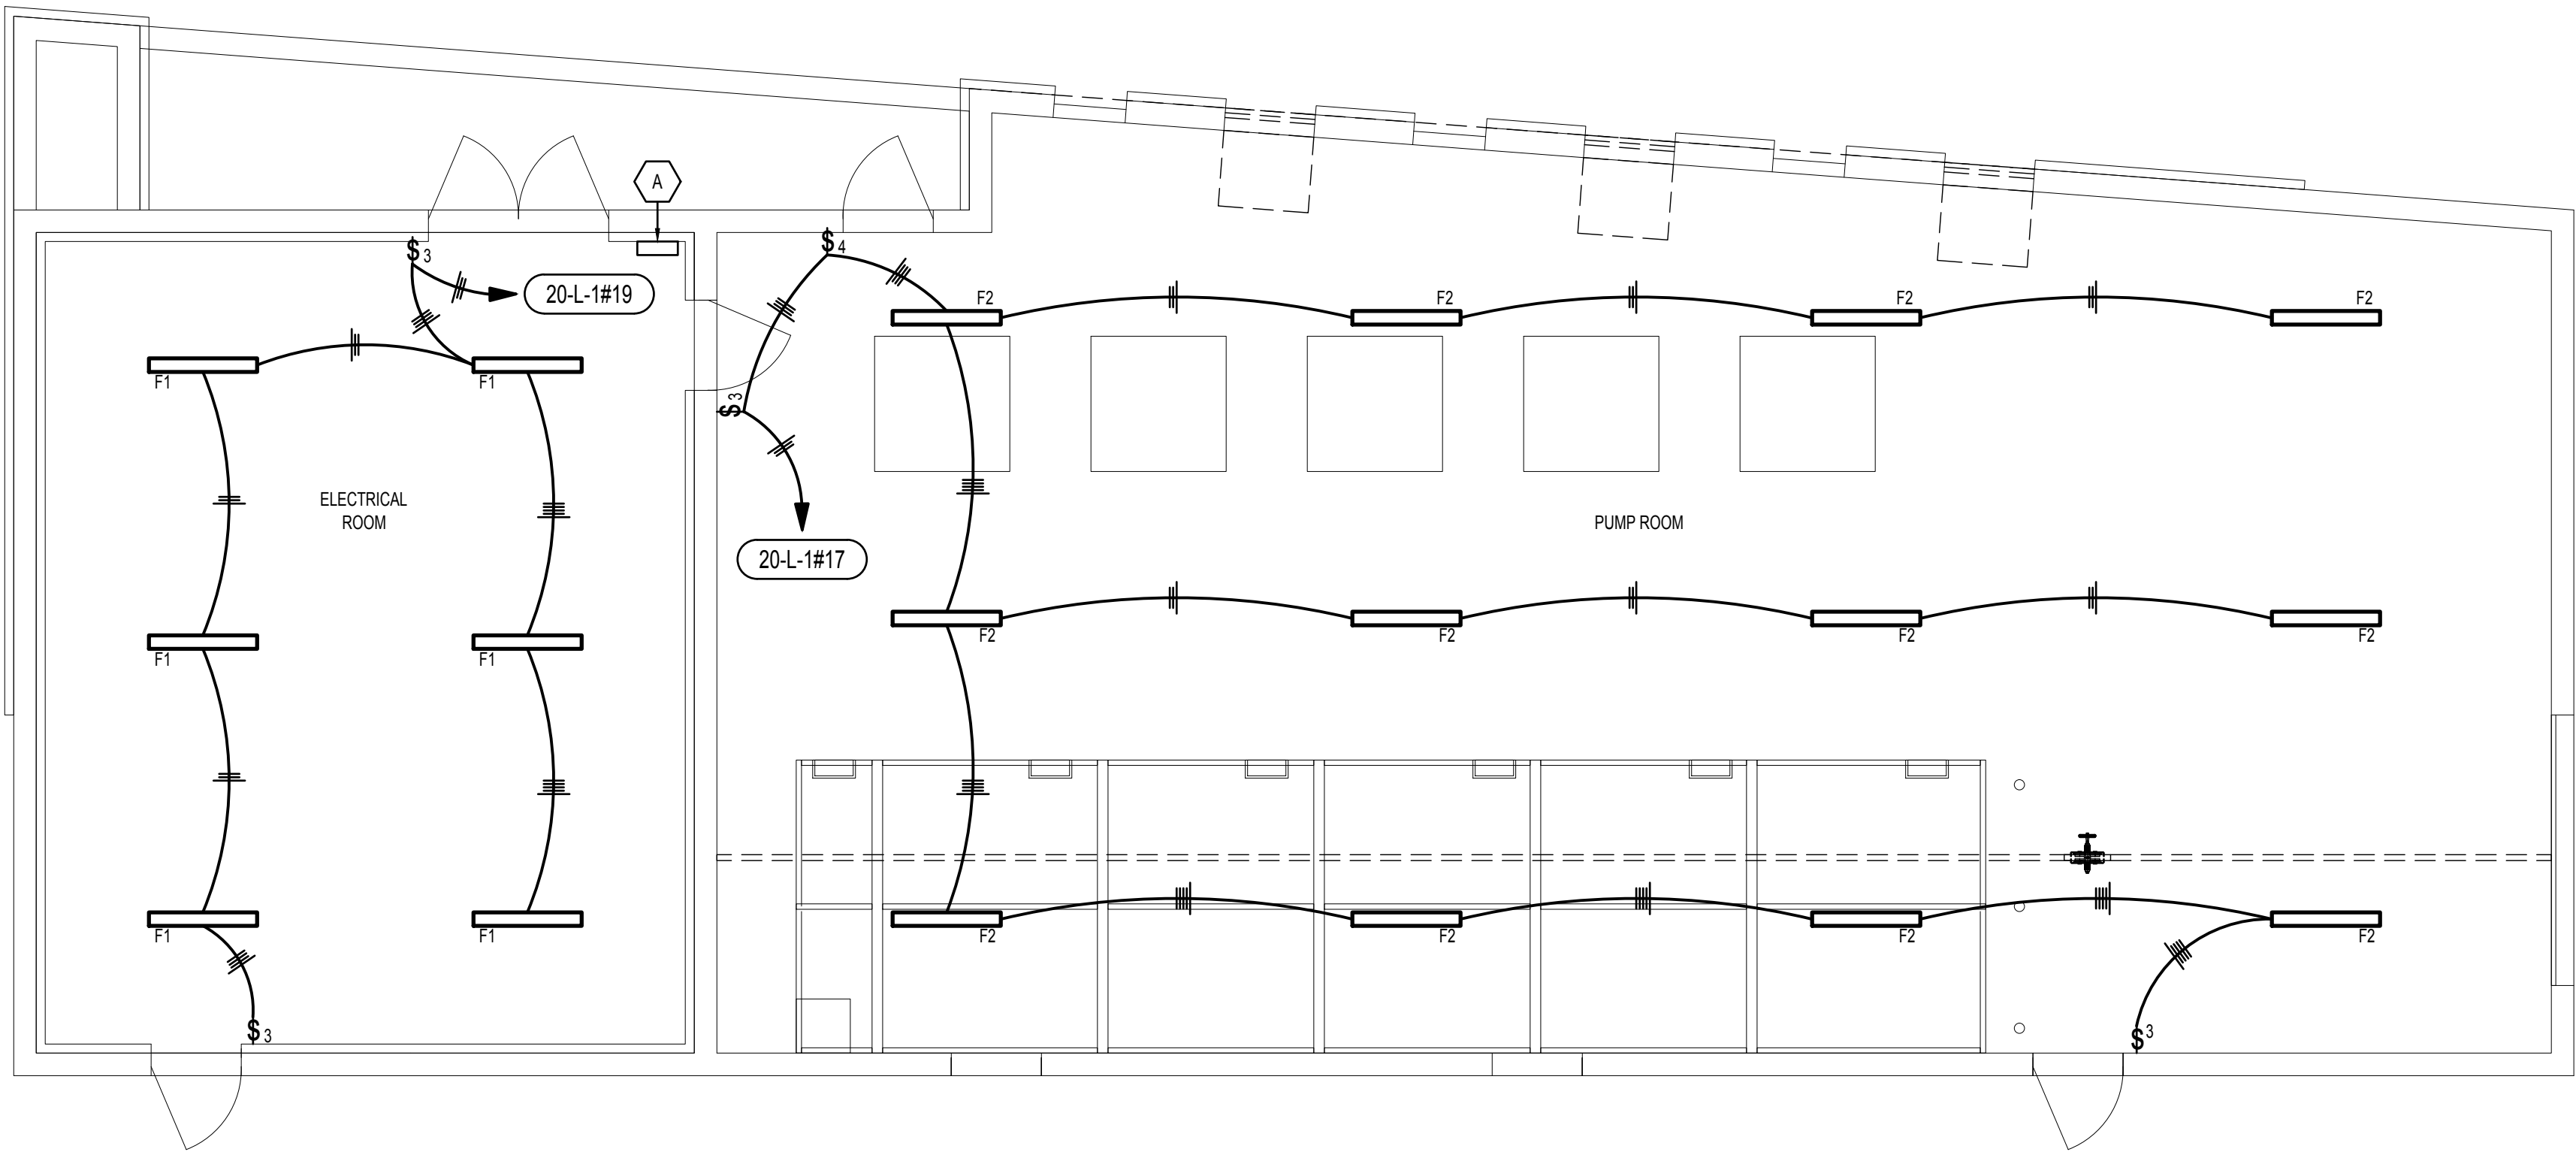

ELECTRICAL LIGHTING PLAN

SCALE: 3/16" = 1'

 VERIFY SCALE
BAR IS ONE INCH ON ORIGINAL DRAWING



KEY NOTES

- A LIGHTING CONTACTOR FOR THE EXTERIOR LIGHTS. SEE 01-E101 FOR EXTERIOR LIGHT LOCATIONS.

GENERAL NOTES

- FIXTURES IN ELECTRICAL ROOM MOUNTED AT 10ft SUSPENDED FROM CEILING.
- FIXTURES IN PUMP ROOM MOUNTED AT 17ft SUSPENDED FROM CEILING.
- SEE SHEET 20-E602 FOR LIGHTING FIXTURE SCHEDULE



PROJECT

PROVO RIVER
WATER TREATMENT
PLANT


CLIENT

PROVO CITY
PUBLIC WORKS
1377 South 350 East
Provo, UT 84606
Tel: (801) 852-6700



CONSULTANTS

AECOM
756 East Winchester Street
Salt Lake City, UT 84107
Tel: (801) 904-4000 Fax: (801) 904-4100
http:// www.aecom.com
Hansen, Allen & Luce, Inc.
859 West South Jordan Pkwy, Ste 200
South Jordan, UT 84095
Tel: (801) 566-6599
http:// www.hansenallenluce.com

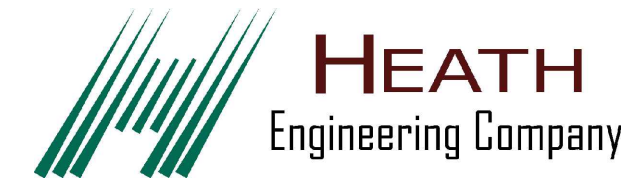

REGISTRATION



ISSUE/REVISION

B	2023-04-07	ISSUED FOR BID
A	2023-01-20	ISSUED FOR 90%
I/R	DATE	DESCRIPTION

PROJECT NUMBER

AECOM Project No. - 60670884
HAL Project No. - 035.15.420

SHEET TITLE


CLEARWELL AND
PUMP STATION
ELECTRICAL
PUMP STATION LIGHTING
PLAN

DRAWING NUMBER

20-E105

ANSI D 22" x 34" Approved: R.HILLER Checked: R.HILLER Designer: R.HILLER Drafter: HEATH ENGINEERING Project Manager: R.HILLER

Last Plotted: 14.04.2023
Filename: I:\203701-DWG\REF\2037-PS-G-TBLK.dwg

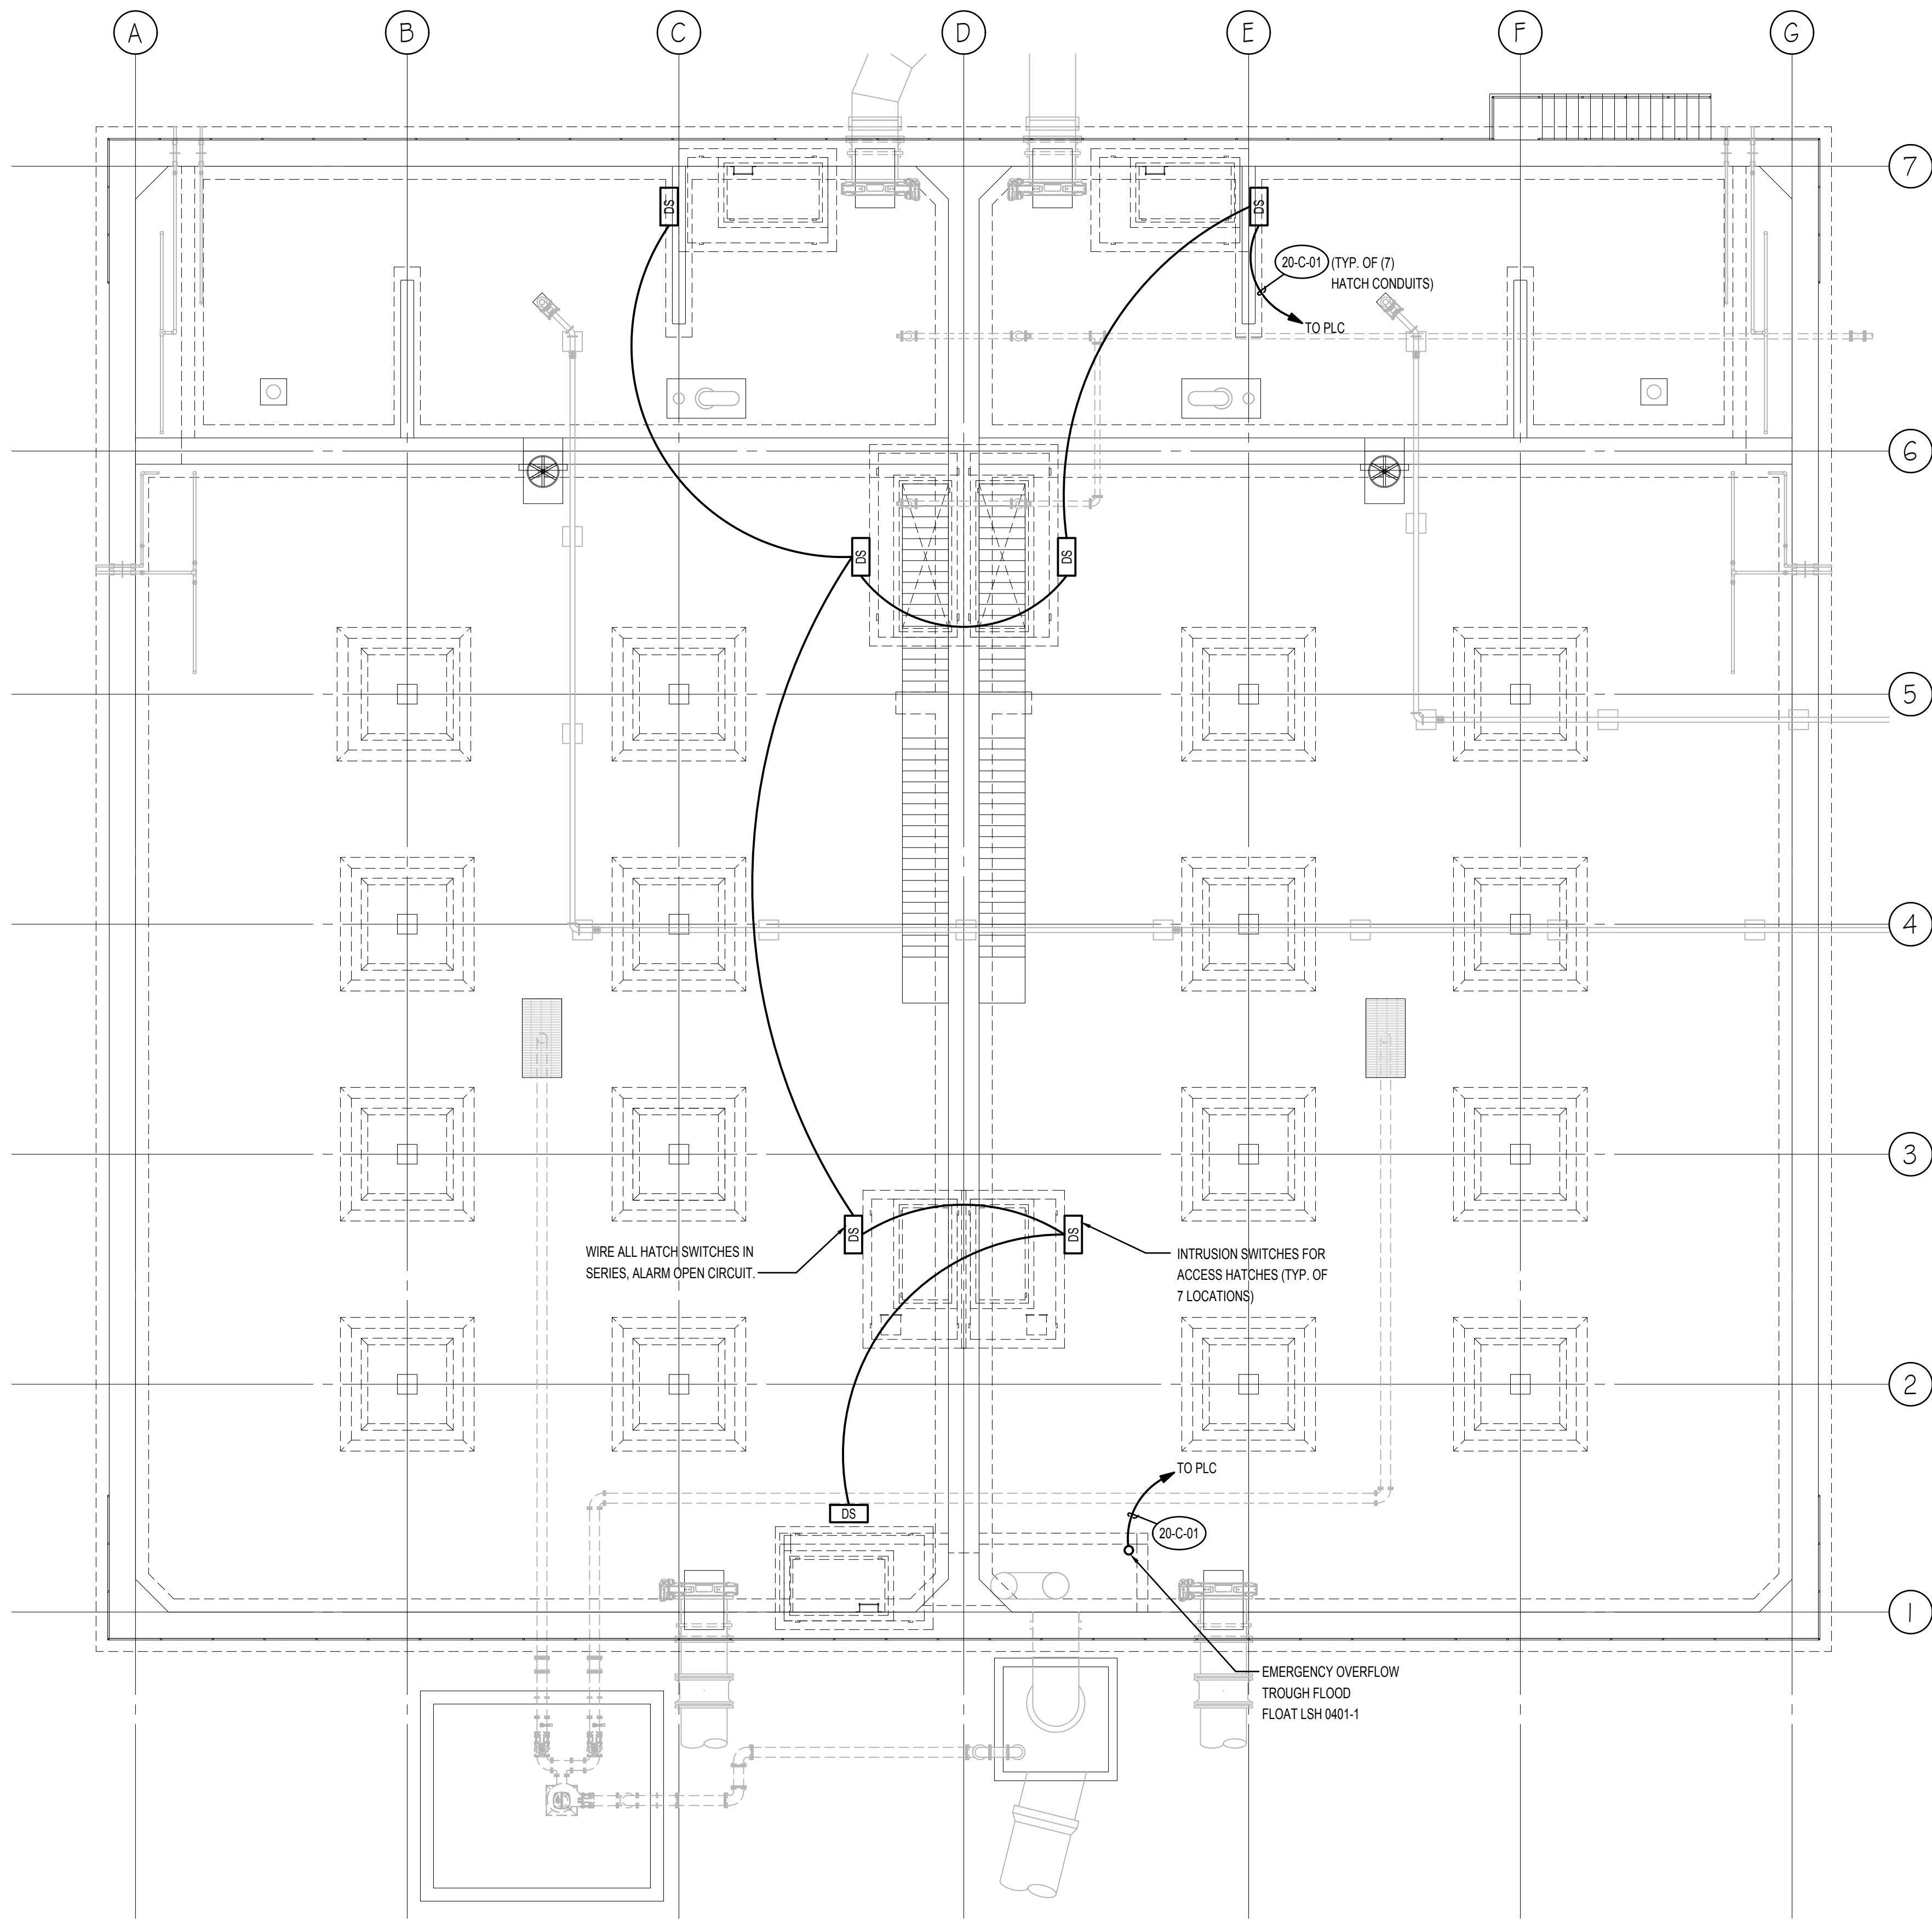

ELECTRICAL CLEARWELL ROOF DECK CONTROL PLAN
SCALE: 3/8" = 1"

VERIFY SCALE
BAR IS ONE INCH ON ORIGINAL DRAWING

N
↑
↓



PROJECT

PROVO RIVER
WATER TREATMENT
PLANT


CLIENT

PROVO CITY
PUBLIC WORKS
1377 South 350 East
Provo, UT 84606
Tel: (801) 852-6700



CONSULTANTS

AECOM
756 East Winchester Street
Salt Lake City, UT 84107
Tel: (801) 904-4000 Fax: (801) 904-4100
http:// www.aecom.com
Hansen, Allen & Luce, Inc.
859 West South Jordan Pkwy, Ste 200
South Jordan, UT 84095
Tel: (801) 586-6599
http:// www.hansenallenluce.com

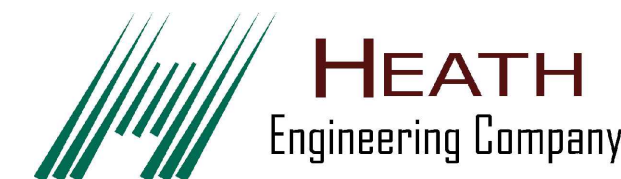

REGISTRATION



ISSUE/REVISION

B	2023-04-07	ISSUED FOR BID
A	2023-01-20	ISSUED FOR 90%
I/R	DATE	DESCRIPTION

PROJECT NUMBER


AECOM Project No. - 60670884
HAL Project No. - 035.15.420

SHEET TITLE

CLEARWELL AND
PUMP STATION
ELECTRICAL
CLEARWELL ROOF DECK
CONTROL PLAN

DRAWING NUMBER

20-E106

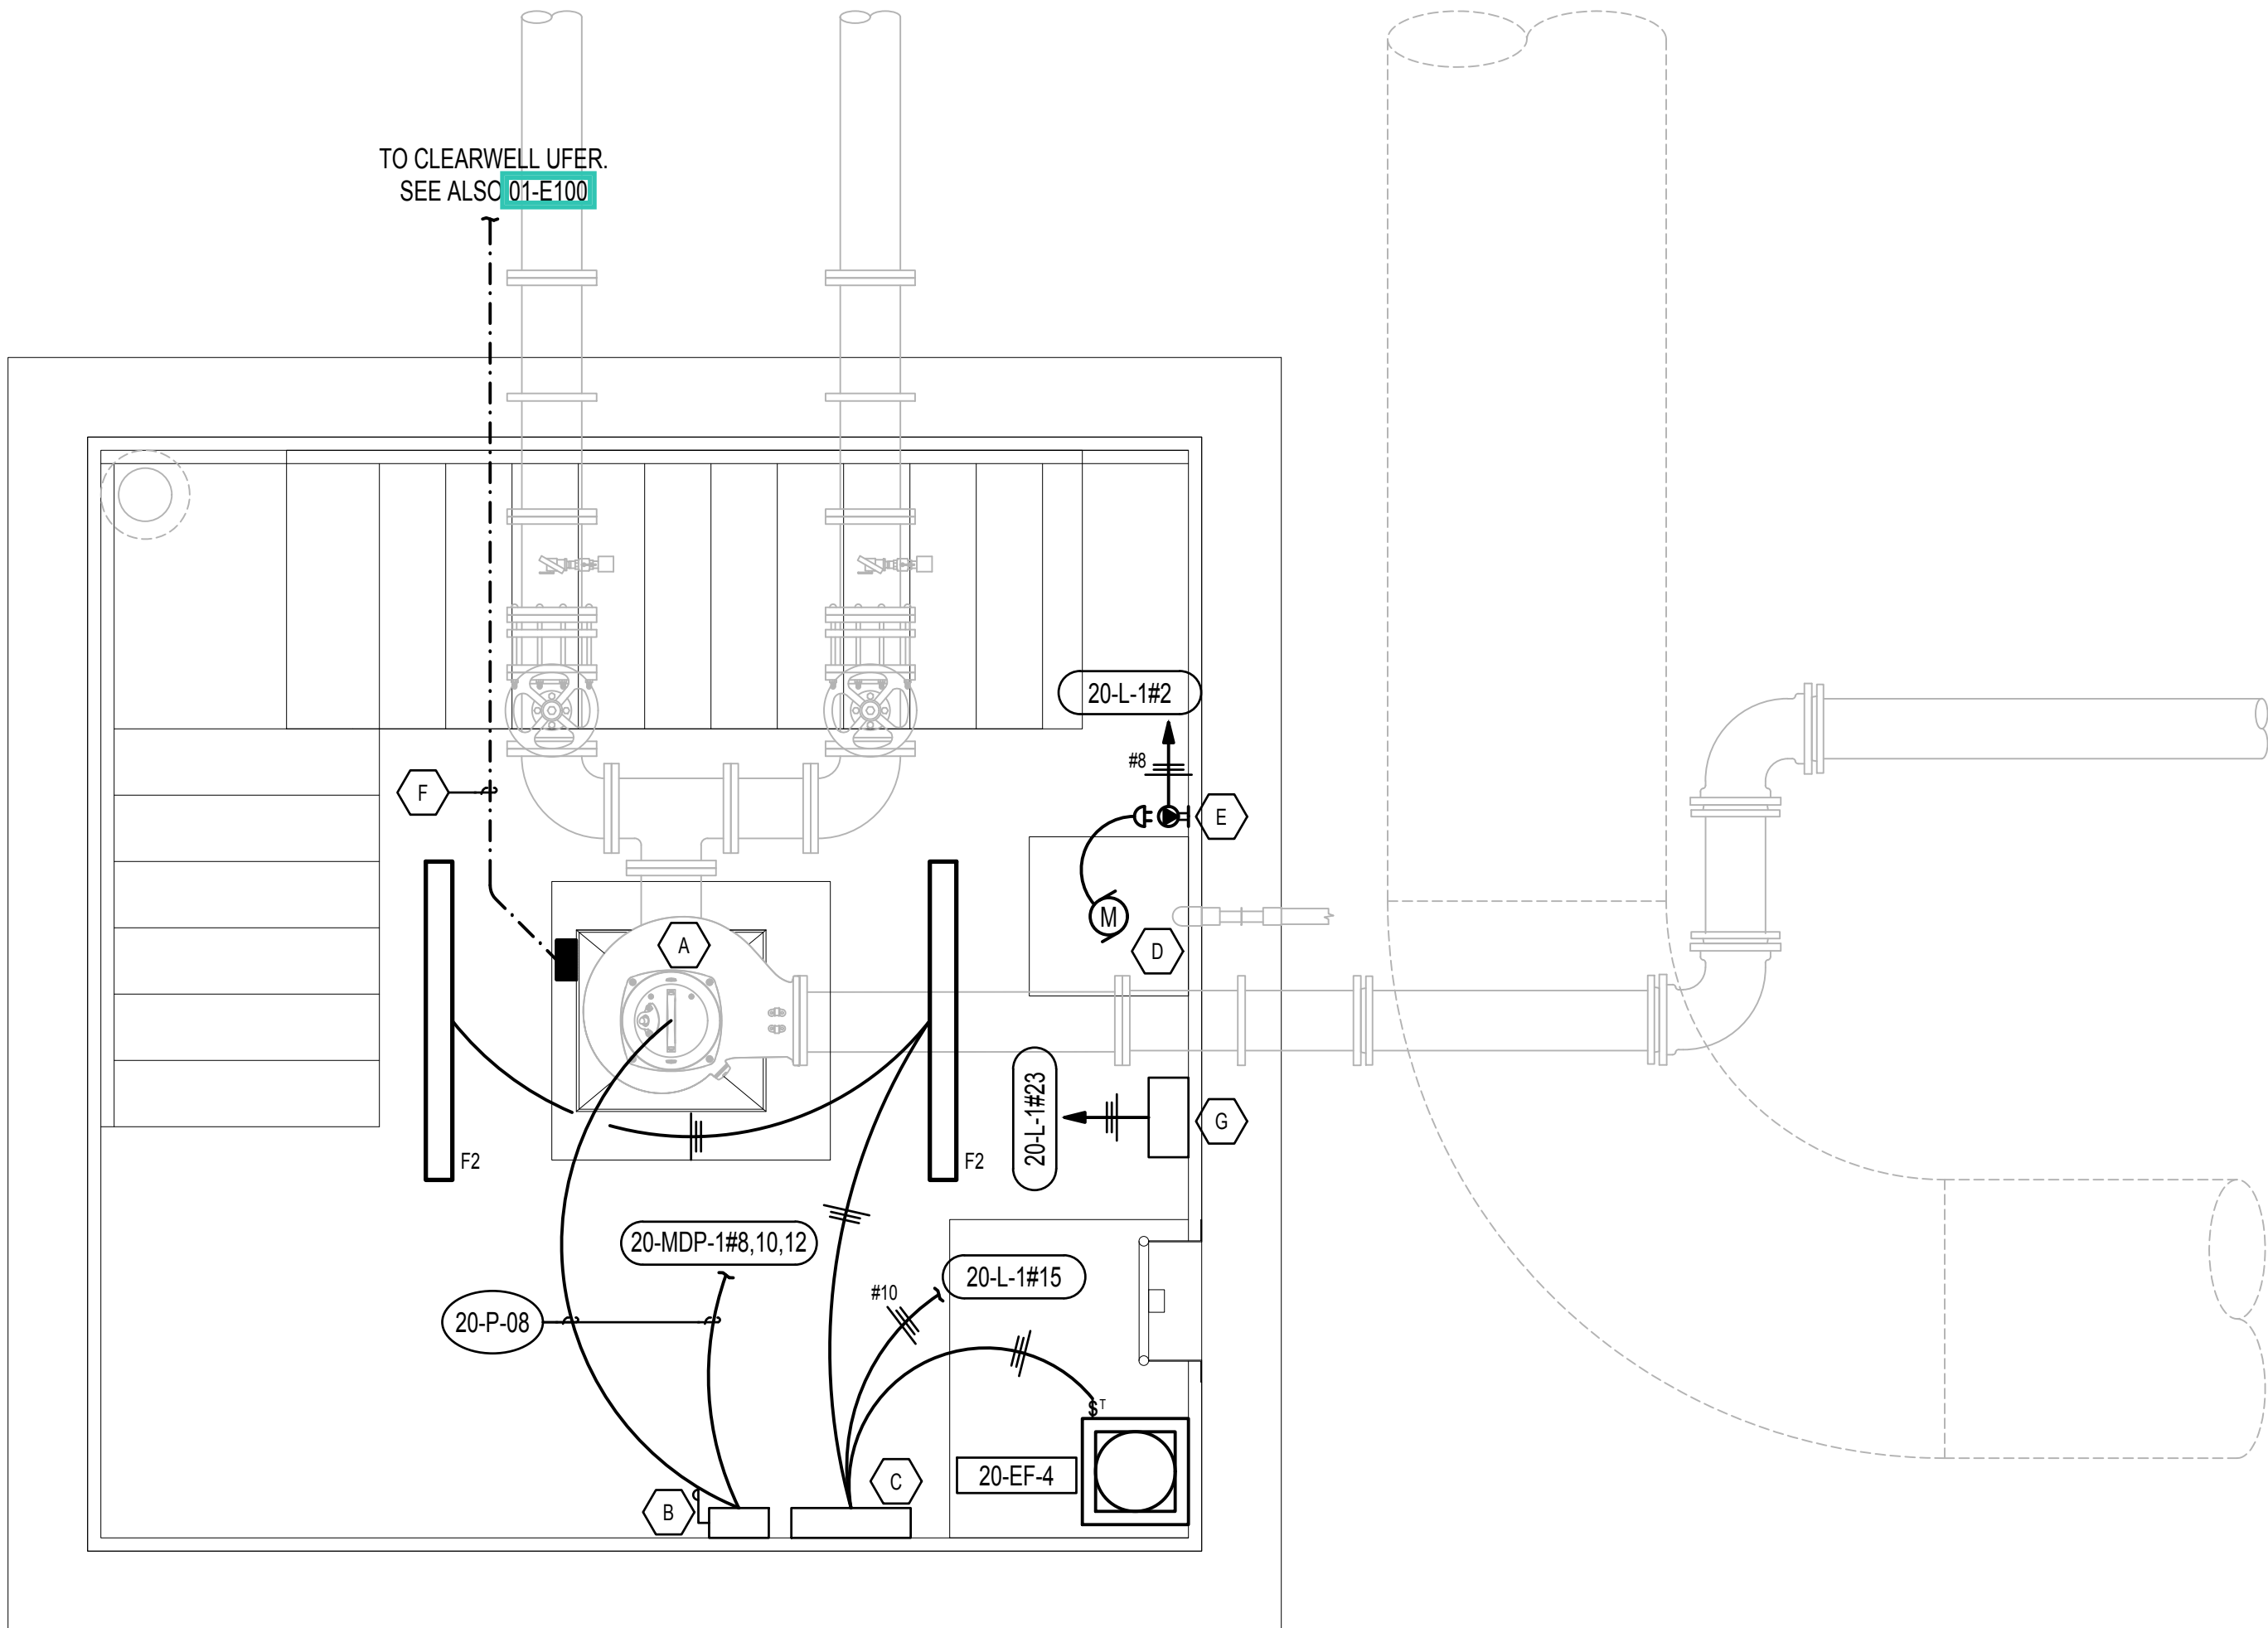**DRAIN VAULT ELECTRICAL POWER PLAN**

SCALE: 1/2" = 1'

VERIFY SCALE

BAR IS ONE INCH ON ORIGINAL DRAWING


**KEY NOTES**

- A DRAIN PUMP PMP-0403-1
- B DRAIN PUMP CONTROL PANEL LCP-0403-1 NEMA 4X
- C LIGHTING CONTROL BOX. DOOR SWITCHES ON THE ENTRY AND PUMP HATCHES TURN ON LIGHTS AND EXHAUST FAN AND SENDS INTRUSION ALARM NEMA 4X. SEE ALSO 20-E108
- D SUMP PUMP PMP-0403-02
- E 120V 20A LOCKING RECEPTACLE FOR SUMP
- F #8 B.C. GROUNDING ELECTRODE
- G CHLORINE ANALYZER. AE 0403-1 / AIT 0403-1

AECOM
HANSEN
ALLEN
& LUCE inc
E N G I N E E R S**PROJECT****PROVO RIVER
WATER TREATMENT
PLANT****CLIENT****PROVO CITY
PUBLIC WORKS**
1377 South 350 East
Provo, UT 84606
Tel: (801) 852-6700**CONSULTANTS**


AECOM
756 East Winchester Street
Salt Lake City, UT 84107
Tel: (801) 904-4000 Fax: (801) 904-4100
http:// www.aecom.com

Hansen, Allen & Luce, Inc.
859 West South Jordan Pkwy, Ste 200
South Jordan, UT 84095
Tel: (801) 586-6599
http:// www.hansenallenluce.com

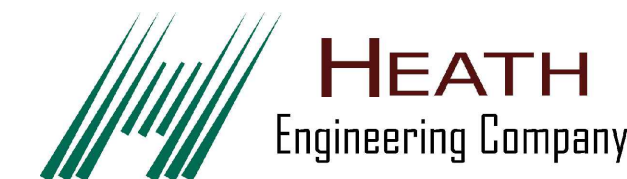
**REGISTRATION****ISSUE/REVISION**

B	2023-04-07	ISSUED FOR BID
A	2023-01-20	ISSUED FOR 90%
I/R	DATE	DESCRIPTION

PROJECT NUMBERAECOM Project No. - 60670884
HAL Project No. - 035.15.420**SHEET TITLE****CLEARWELL AND
PUMP STATION
ELECTRICAL
DRAIN VAULT POWER
PLAN****DRAWING NUMBER****20-E107**

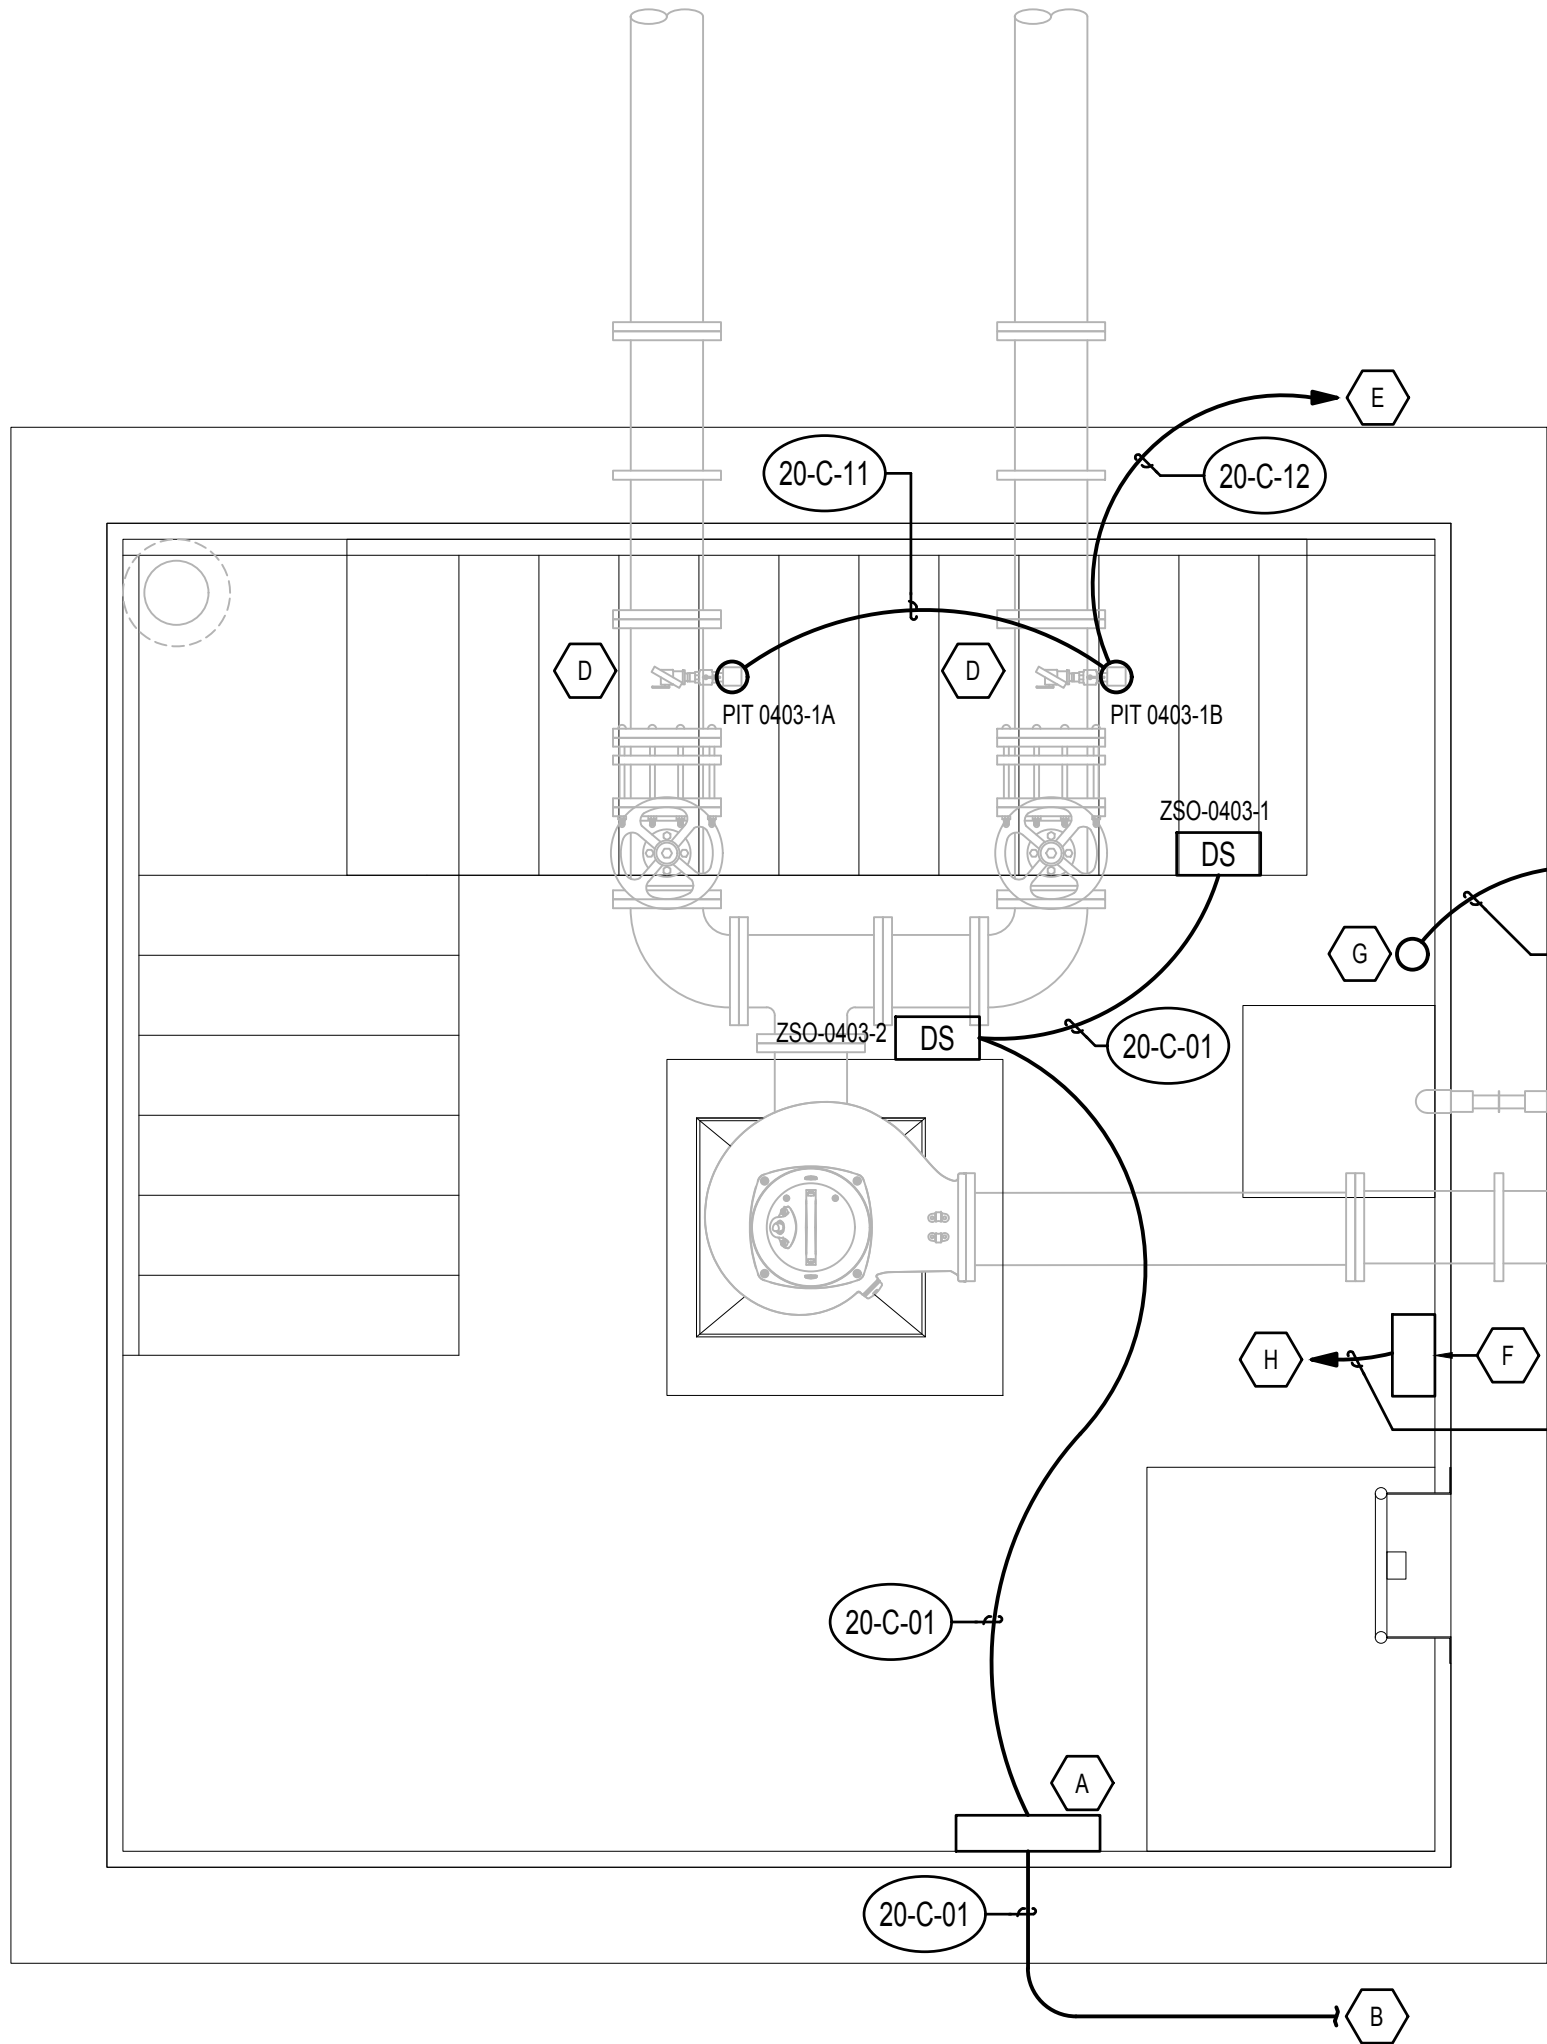

DRAIN VAULT ELECTRICAL CONTROL PLAN
SCALE: 1/2" = 1'

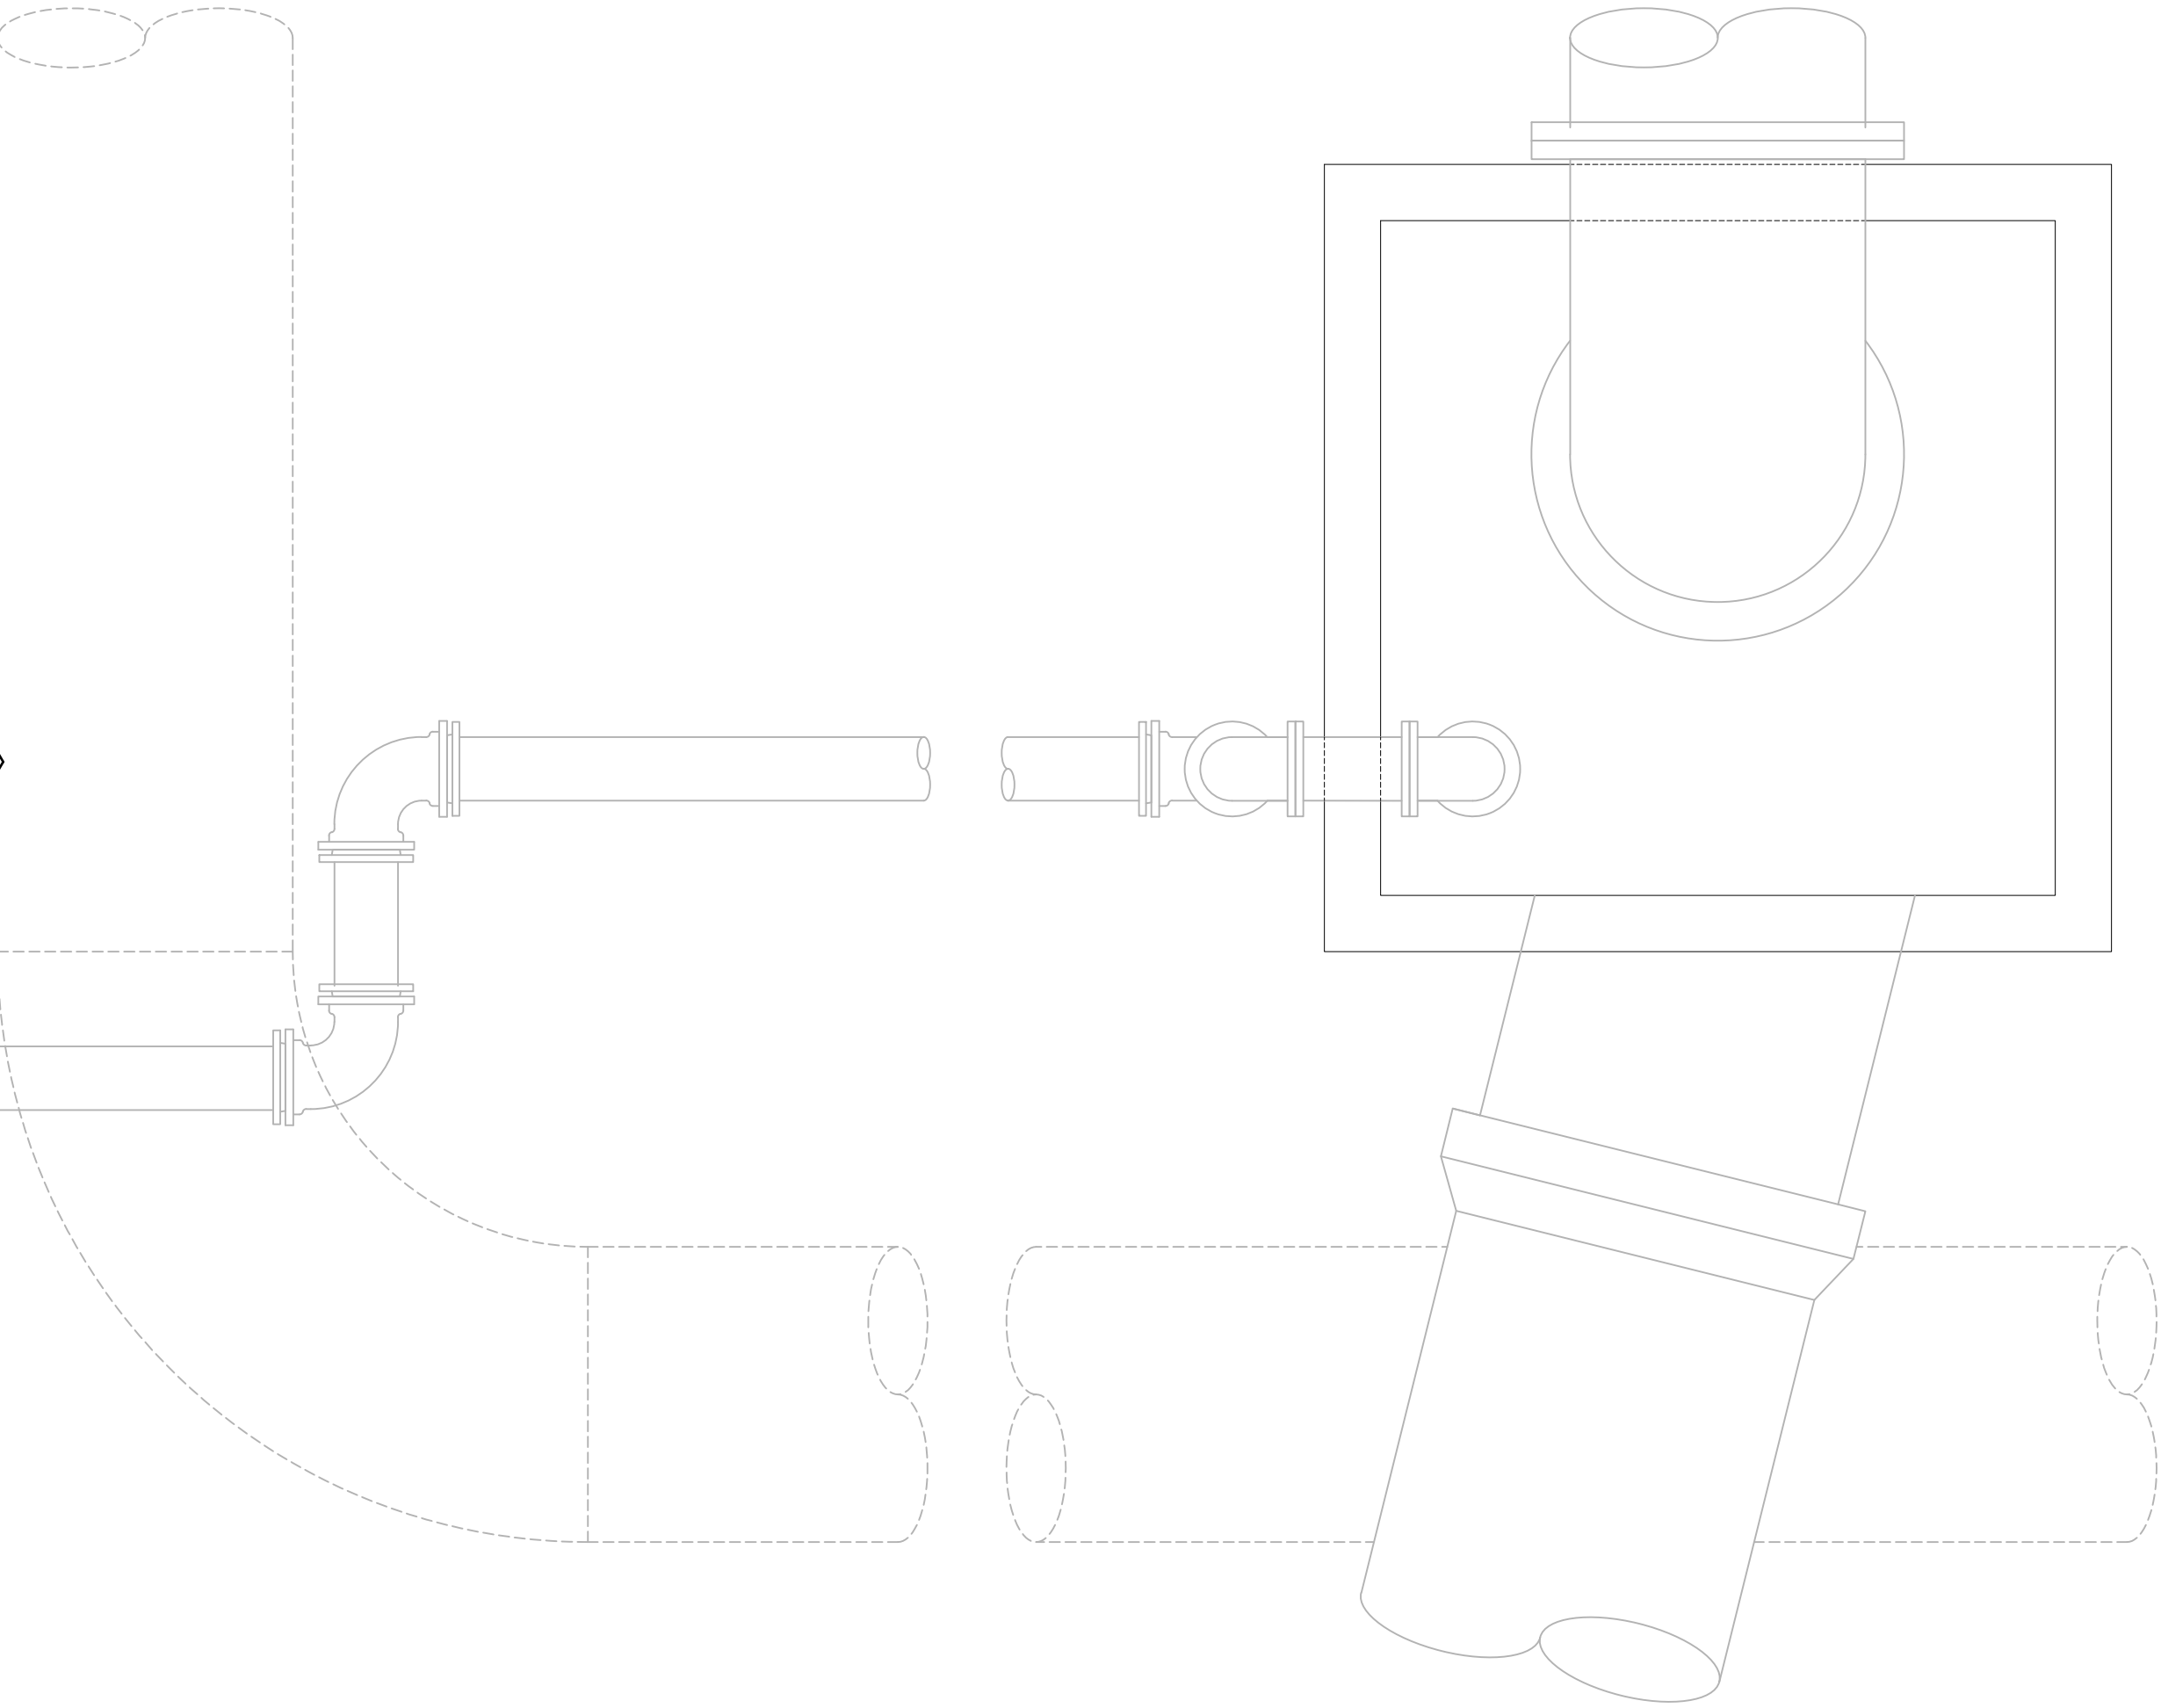

EMERGENCY OVERFLOW BOX CONTROL PLAN
SCALE: 1/2" = 1'

VERIFY SCALE

BAR IS ONE INCH ON ORIGINAL DRAWING

N

- KEY NOTES
- A

 LIGHTING CONTROL BOX
- B

 TO PLC INTRUSION ALARM
- C

 TO PLC FLOOD ALARM
- D

 PRESSURE TRANSDUCER FOR TANK LEVEL
- E

 TO PLC TANK LEVEL
- F

 CHLORINE ANALYZER AE 0403-1 / AIT 0403-1
- G

 FLOOD FLOAT LSHH 043-1
- H

 TO PLC CHLORINE VALVE



PROJECT

PROVO RIVER
WATER TREATMENT
PLANT


CLIENT

PROVO CITY
PUBLIC WORKS
1377 South 350 East
Provo, UT 84606
Tel: (801) 852-6700



CONSULTANTS

AECOM
756 East Winchester Street
Salt Lake City, UT 84107
Tel: (801) 904-4000 Fax: (801) 904-4100
http:// www.aecom.com
Hansen, Allen & Luce, Inc.
859 West South Jordan Pkwy, Ste 200
South Jordan, UT 84095
Tel: (801) 586-6599
http:// www.hansenallenluce.com

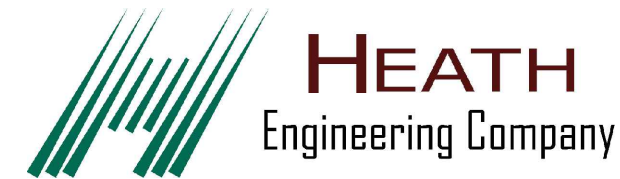

REGISTRATION



ISSUE/REVISION

B	2023-04-07	ISSUED FOR BID
A	2023-01-20	ISSUED FOR 90%
I/R	DATE	DESCRIPTION

PROJECT NUMBER


AECOM Project No. - 60670884
HAL Project No. - 035.15.420

SHEET TITLE

CLEARWELL AND
PUMP STATION
ELECTRICAL
DRAIN VAULT / OF BOX
CONTROL PLAN

DRAWING NUMBER

20-E108

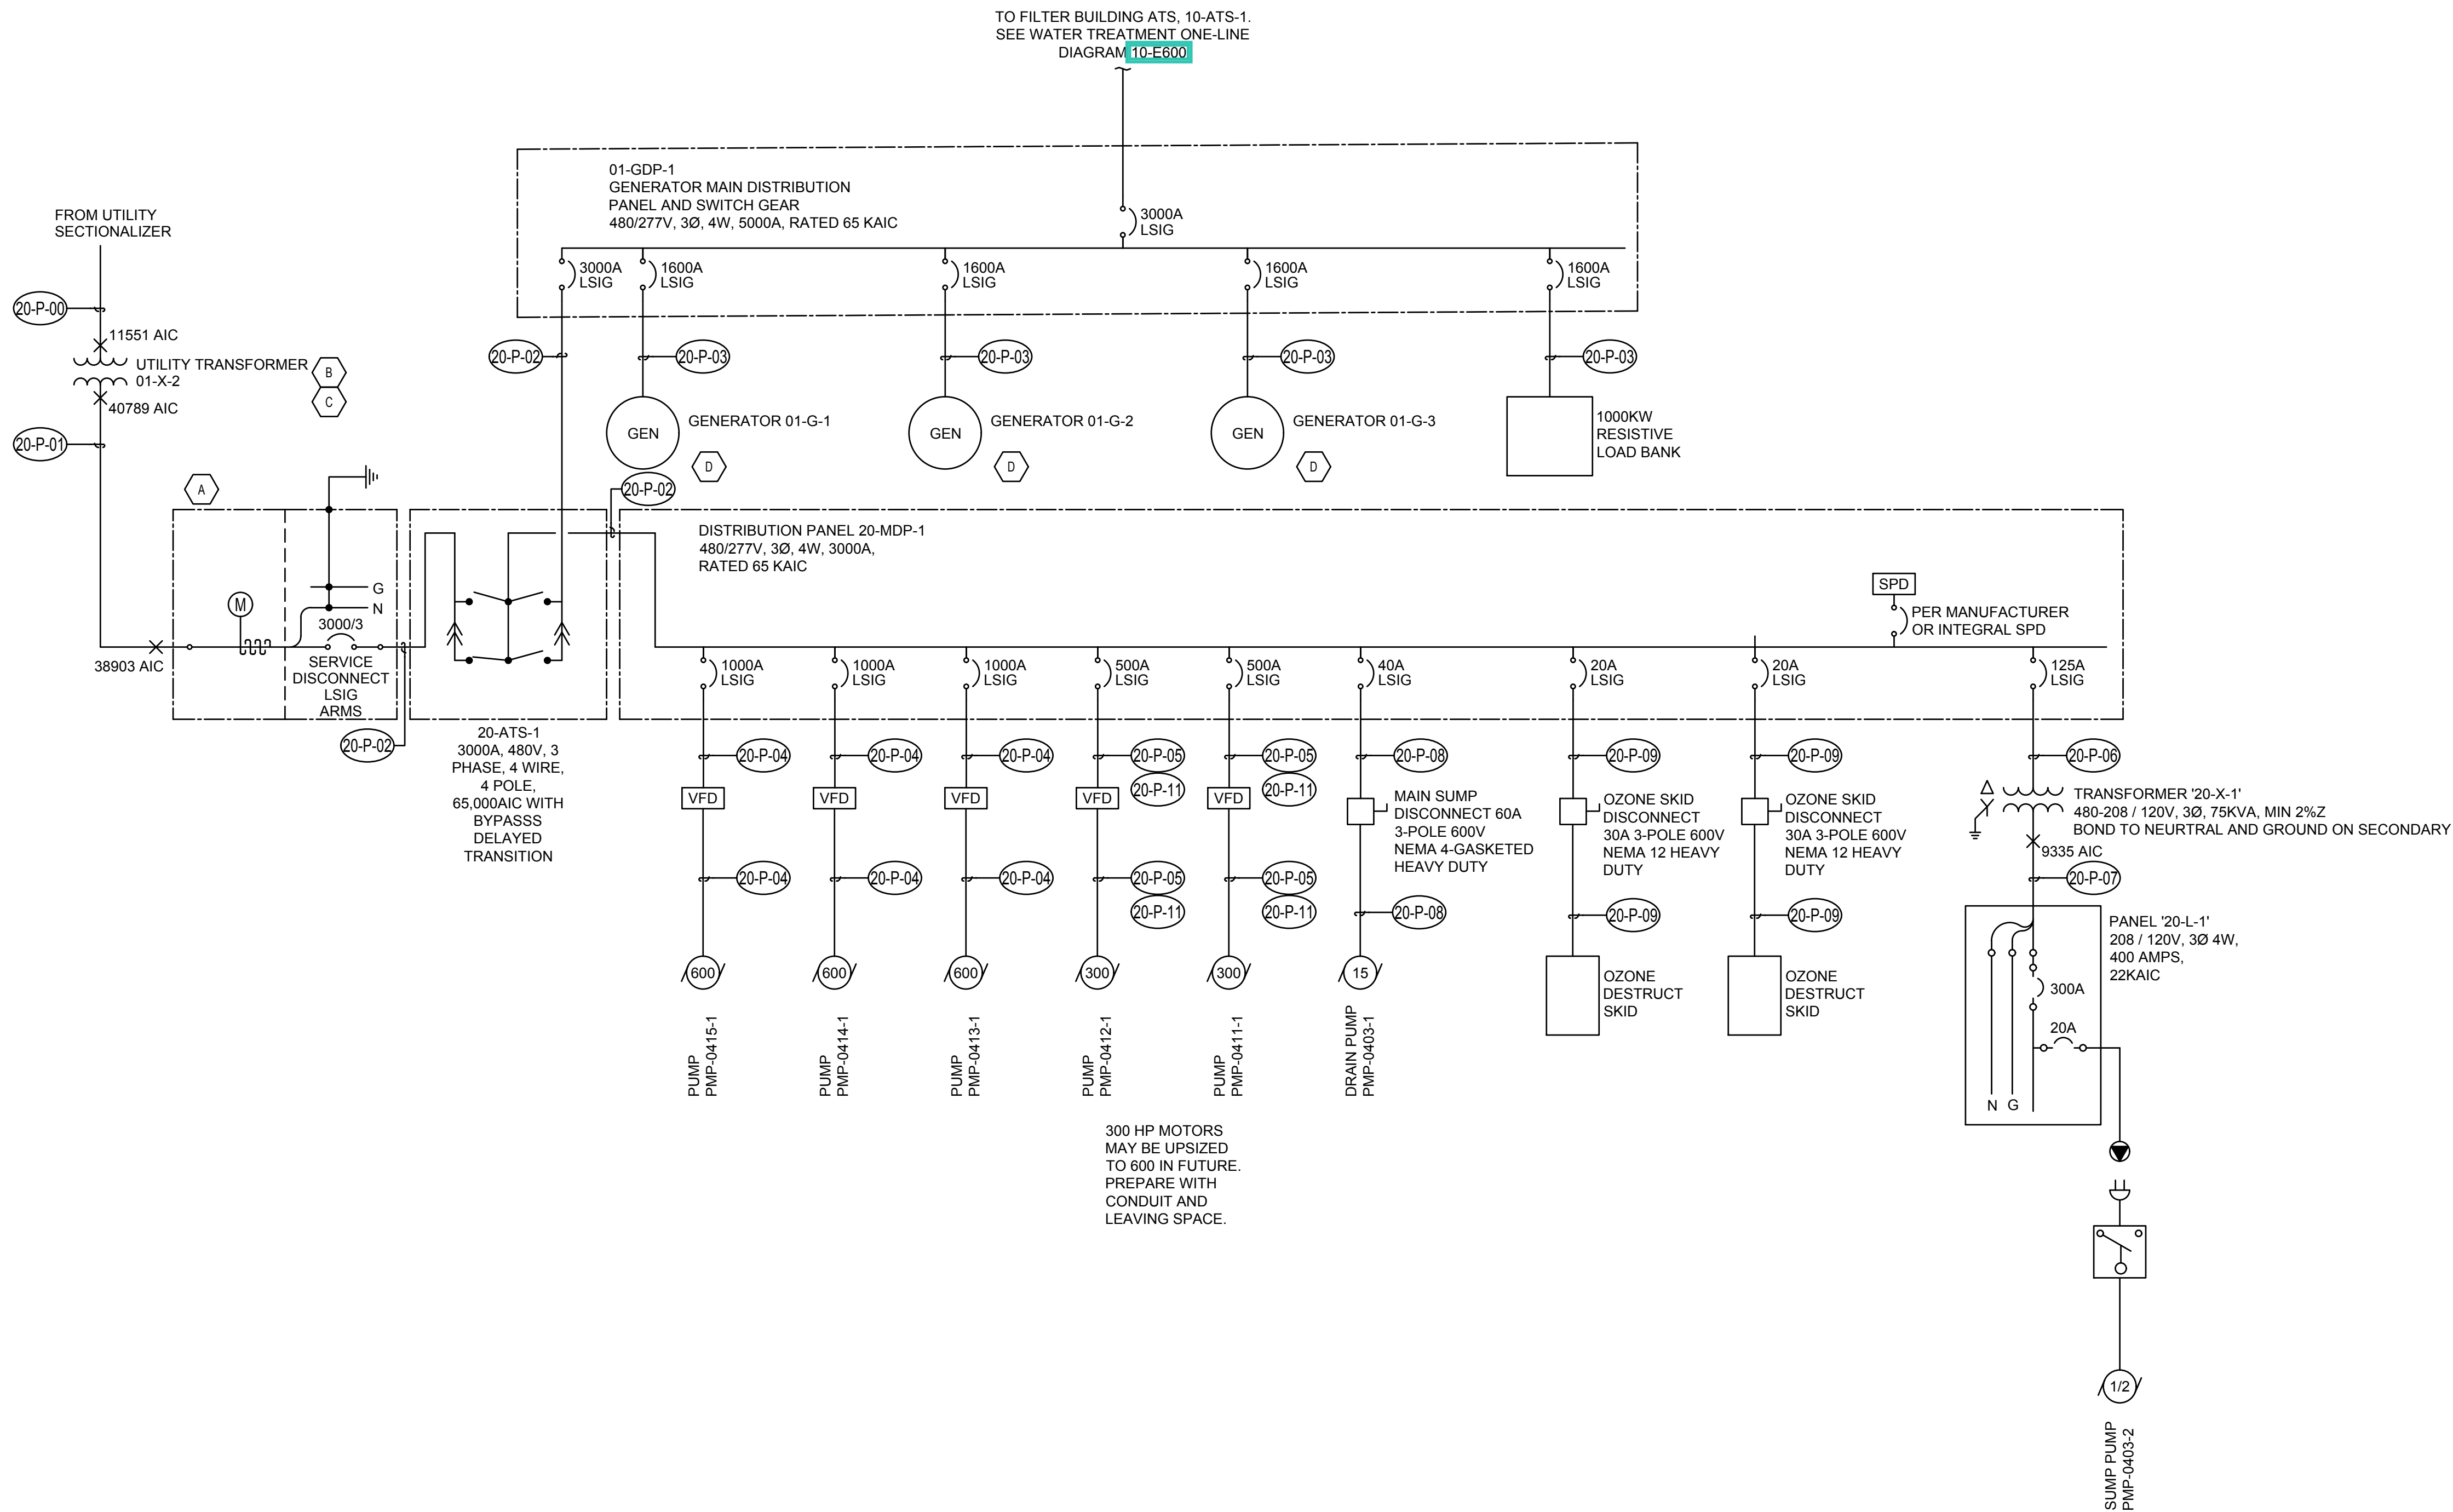

BAR IS ONE INCH ON ORIGINAL DRAWING

A	UTILITY METERING SECTION. UTILITY METERING SECTION NEMA 3R. PROVIDE COVER OVER METERING SECTION. INCLUDE SHORTING BLOCKS, TEST BLOCKS AT METER. CT'S AND METERING EQUIPMENT PROVIDED BY UTILITY.
B	UTILITY TRANSFORMER 480 / 277V, 3Ø, 4W
C	PAD VAULT BY CONTRACTOR
D	STANDBY GENERATOR 1000KW 480 / 277V

PROJECT

PROVO RIVER WATER TREATMENT PLANT


CLIENT

**PROVO CITY
PUBLIC WORKS**
1377 South 350 East
Provo, UT 84606
Tel: (801) 852-6700



CONSULTANTS

AECOM
756 East Winchester Street
Salt Lake City, UT 84107
Tel: (801) 904-4000 Fax: (801) 904-4100
<http://www.aecom.com>
Hansen, Allen & Luce, Inc.
859 West South Jordan Pkwy, Ste 200
South Jordan, UT 84095
Tel: (801) 566-5599
<http://www.hansenallenluce.com>

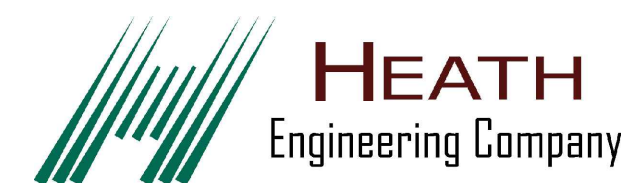

REGISTRATION



ISSUE/REVISION

B	2023-04-07	ISSUED FOR BID
A	2023-01-20	ISSUED FOR 90%
I/R	DATE	DESCRIPTION

PROJECT NUMBER

AECOM Project No. - 60670884
HAL Project No. - 035.15.420

SHEET TITLE

CLEARWELL AND PUMP STATION ELECTRICAL ONE-LINE DIAGRAM

DRAWING NUMBER

20-E601

POWER CONDUIT SCHEDULE

20-P-00	2	WIRE BY UTILITY	4"
20-P-01	7	P: 3 - 500 N: 1 - 500 G: NONE	3-12"
20-P-02	7	P: 3 - 500 N: 1 - 500 G: 1 - 350	3-12"
20-P-03	5	P: 3 - 500 N: NONE G: 1 - 400	3"
20-P-04	3	P: 3 - 500 VFD N: NONE G: 1 - 200	3"
20-P-05	2	P: 3 - 250 VFD N: NONE G: 1 - #2	3"
20-P-06	1	P: 3 - 100 N: NONE G: 1 - #2	1-12"
20-P-07	1	P: 3 - 350 N: 1 - 350 G: 1 - #4	3"
20-P-08	1	P: 3 - #10 N: NONE G: 1 - #10	3/4"
20-P-09	1	P: 3 - #12 N: NONE G: 1 - #12	3/4"
20-P-10	1	P: 3 - #12 N: NONE G: 1 - #12	3/4"
20-P-11	1	SPARE	3"
20-P-12	1	P: 2 - #1 N: 1 - #1 G: 1 - #8	2"

CONTROL CONDUIT SCHEDULE




20-C-01	4 - #14, 1 - #14 GND, 3/4"C
20-C-03	8 - #14, 1 - #14 GND, 3/4"C
20-C-09	20 - #14, 1 - #14 GND, 1"C
20-C-10	24 - #14, 1 - #14 GND, 1-1/4"C
20-C-11	1 - #16 TSP, 1 - #14 GND, 3/4"C
20-C-12	2 - #16 TSP, 1 - #14 GND, 3/4"C
20-C-16	6 - #16 TSP, 1 - #14 GND, 1"C
20-C-21	MANUFACTURER'S CABLE, 1"C
20-C-22	(1) CAT 6 CABLE, 1"C
20-C-23	(2) CAT 6 CABLE, 1"C
20-C-24	RTD CABLES, 1-#16 GND, 1"C

PANEL 20-L-1


VOLTAGE: 208/120 V 3Ø 4W				CIRCUIT BREAKER TYPE:				I-LINE				MOUNTING: SURFACE							
ENCLOSURE: NEMA 1				INTERRUPTING CAPACITY:				22 KAIC				COVER TYPE: DOOR-IN-DOOR							
												LOCATION: PUMP BUILDING ELECTRICAL ROOM							
BRANCH CIRCUIT BREAKER				CONNECTION		DESCRIPTION			PHASE			DESCRIPTION		CONNECTION		BRANCH CIRCUIT BREAKER			
NOTES	#	AMP	P.	LOAD (VA)					A	B	C			LOAD (VA)		P.	AMP	#	NOTES
	L-1	20	1	200		SECURITY PANEL			1376			SMALL SUMP		1176		1	20	L-2	
	L-3	20	1	200		NETWORK PANEL				2280		SPLIT A/C 20-SHP-1		2080		2	30	L-4	1
	L-5	20	1	1000		PLC					3080	-----		2080		--	--	L-6	
	L-7	20	1			SPARE			2080			SPLIT A/C 20-SHP-2		2080		2	30	L-8	1
	L-9	20	1	150		FLOW TRANSMITTER FIT-0417-1				2230		-----		2080		--	--	L-10	
	L-11	20	1	900		PUMP ROOM RECEPTACLES					2980	SPLIT A/C 20-SHP-3		2080		2	30	L-12	1
	L-13	20	1	900		ELEC ROOM RECEPTACLES			2980			-----		2080		--	--	L-14	
	L-15	20	1	752		DRAIN VAULT LIGHTS AND FAN				2832		SPLIT A/C 20-SHP-4		2080		2	30	L-16	1
	L-17	20	1	900		PUMP ROOM LIGHTS					2980	-----		2080		--	--	L-18	
	L-19	20	1	303		ELEC ROOM LIGHTS			2383			SPLIT A/C 20-SHP-5		2080		2	30	L-20	1
	L-21	20	1	381		EXTERIOR LIGHTS VIA LIGHTING RELAY				2461		-----		2080		--	--	L-22	
	L-23	20	1	150		CHLORINE ANALYZER 0418-1B					2230	SPLIT A/C 20-SHP-6		2080		2	30	L-24	1
	L-25	20	1	150		WATER QUALITY ANALYZER 0418-1A			2230			-----		2080		--	--	L-26	
	L-27	20	1	150		EAST CLEARWELL LEVEL LIT-0401-1				2230		SPLIT A/C 20-SHP-7		2080		2	30	L-28	1
	L-29	20	1	150		EAST CLEARWELL LEVEL LIT-0402-1					2230	-----		2080		--	--	L-30	
1	L-31	100	2	8640		GENERATOR 01-G-1 AUXILIARIES			10720			SPLIT A/C 20-SHP-8		2080		2	30	L-32	1
	L-33	--	--	8640		-----				10720		-----		2080		--	--	L-34	
1	L-35	100	2	8640		GENERATOR 01-G-2 AUXILIARIES					9045	TRANSMISSION PIPELINE VALVE VAULT		405		1	20	L-36	
	L-37	--	--	8640		-----			8640			SPARE						L-38	
	L-39	100	2	8640		GENERATOR 01-G-2 AUXILIARIES				8640		SPARE						L-40	
	L-41	--	--	8640		-----					8640	SPARE						L-42	
	L-43	20	1			SPARE			0			SPARE						L-44	
	L-45	20	1			SPARE				0		SPARE						L-46	
	L-47	20	1			SPARE					0	SPARE						L-48	
	L-49	20	1			SPARE			0			SPARE						L-50	
	L-51	20	1			SPARE				0		SPARE						L-52	
	L-53	20	1			SPARE					0	SPARE						L-54	
PHASE SUBTOTALS (VA)									30409	31393	31185								
PHASE TOTALS (KVA)									30.4	31.4	31.2								
PHASE TOTALS @ 120V (AMPS)									253.4	261.6	259.9								
NOTES:																			
GEN PROVIDE INTEGRAL SPD																			
1 GENERATOR HEATING ELEMENTS AND A/C UNITS NOT EXPECTED TO RUN AT THE SAME TIME.																			
2																			
3																			

PANEL 20-MDP-1

VOLTAGE: 480/277 V 3Ø 4W				CIRCUIT BREAKER TYPE:				I-LINE				MOUNTING: SURFACE							
ENCLOSURE: NEMA 1				INTERRUPTING CAPACITY:				65 KAIC				COVER TYPE: DOOR-IN-DOOR							
												LOCATION: PUMP BUILDING ELECTRICAL ROOM							
BRANCH CIRCUIT BREAKER				CONNECTION		DESCRIPTION			PHASE			DESCRIPTION		CONNECTION		BRANCH CIRCUIT BREAKER			
NOTES	#	AMP	P.	LOAD (VA)					A	B	C			LOAD (VA)		P.	AMP	#	NOTES
	MDP-1	500	3	99997		PUMP PMP-0411-1			130406			TRANSFORMER 20-X-1		30409		3	125	MDP-2	
	MDP-3	--	--	99997		-----				131390		-----		31393		--	--	MDP-4	
	MDP-5	--	--	99997		-----					131182	-----		31185		--	--	MDP-6	
	MDP-7	500	3	99997		PUMP PMP-0412-1			105814			MAIN SUMP PMP-0403-1		5817		3	40	MDP-8	
	MDP-9	--	--	99997		-----				105814		-----		5817		--	--	MDP-10	
	MDP-11	--	--	99997		-----					105814	-----		5817		--	--	MDP-12	
	MDP-13	1000	3	204980		PUMP PMP-0413-1			207251			OZONE SKID		2271		3	20	MDP-14	
	MDP-15	--	--	204980		-----				207251		-----		2271		--	--	MDP-16	
	MDP-17	--	--	204980		-----					207251	-----		2271		--	--	MDP-18	
	MDP-19	1000	3	204980		PUMP PMP-0414-1			207251			OZONE SKID		2271		3	20	MDP-20	
	MDP-21	--	--	204980		-----				207251		-----		2271		--	--	MDP-22	
	MDP-23	--	--	204980		-----					207251	-----		2271		--	--	MDP-24	
1	MDP-25	1000	1			PUMP PMP-0415-1			4167			ELECTRIC UNIT HEATER 20-UH-1		4167		3	20	MDP-26	
	MDP-27	--	--			-----				4167		-----		4167		--	--	MDP-28	
	MDP-29	--	--			-----					4167	-----		4167		--	--	MDP-30	
	MDP-31	20	3	582		EXHAUST FAN 20-EF-1			4748.7			ELECTRIC UNIT HEATER 20-UH-2		4167		3	20	MDP-32	
	MDP-33	--	--	582		-----				4748.7		-----		4167		--	--	MDP-34	
	MDP-35	--	--	582		-----					4748.7	-----		4167		--	--	MDP-36	
	MDP-37	20	3	582		EXHAUST FAN 20-EF-2			1163.4			EXHAUST FAN 20-EF-3		582		3	20	MDP-38	
	MDP-39	--	--	582		-----				1163.4		-----		582		--	--	MDP-40	
	MDP-41	--	--	582		-----					1163.4	-----		582		--	--	MDP-42	
	MDP-43					PROVISION			1330			OVERHEAD DOOR		1330		3	20	MDP-44	
	MDP-45					PROVISION				1330		-----		1330		--	--	MDP-46	
	MDP-47					PROVISION					1330	-----		1330		--	--	MDP-48	
	MDP-49					PROVISION			0			PROVISION						MDP-50	
	MDP-51					PROVISION				0		PROVISION						MDP-52	
	MDP-53					PROVISION					0	PROVISION						MDP-54	
PHASE SUBTOTALS (VA)									662131	663115	662907								
PHASE TOTALS (KVA)									662.1	663.1	662.9								
PHASE TOTALS @ 277V (AMPS)									2390.4	2393.9	2393.2								
NOTES:																			
1 LOAD NOT INCLUDED. MAXIMUM OF 1800HP AT ANY ONE TIME. EXHAUST FAN AND HEATER WON'T RUN AT THE SAME TIME.																			
2																			
3																			
4																			

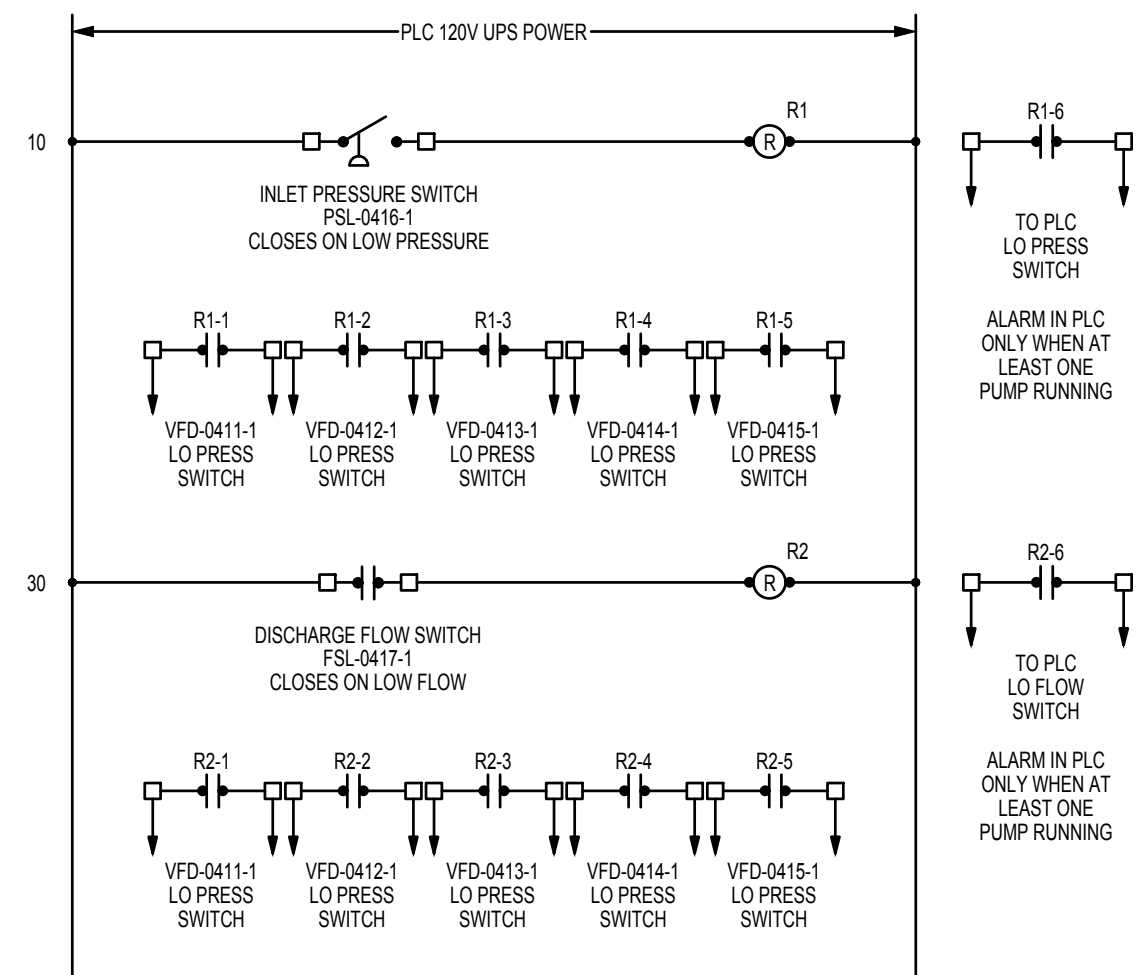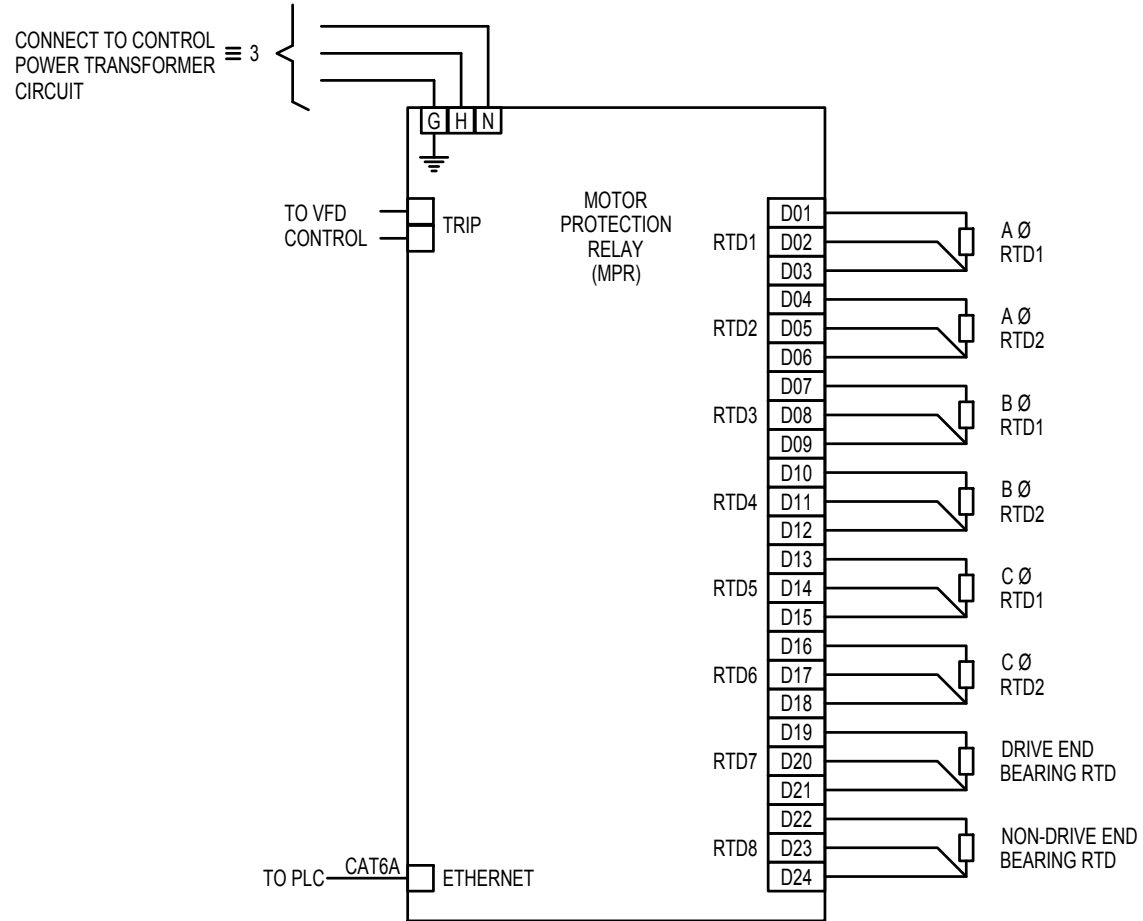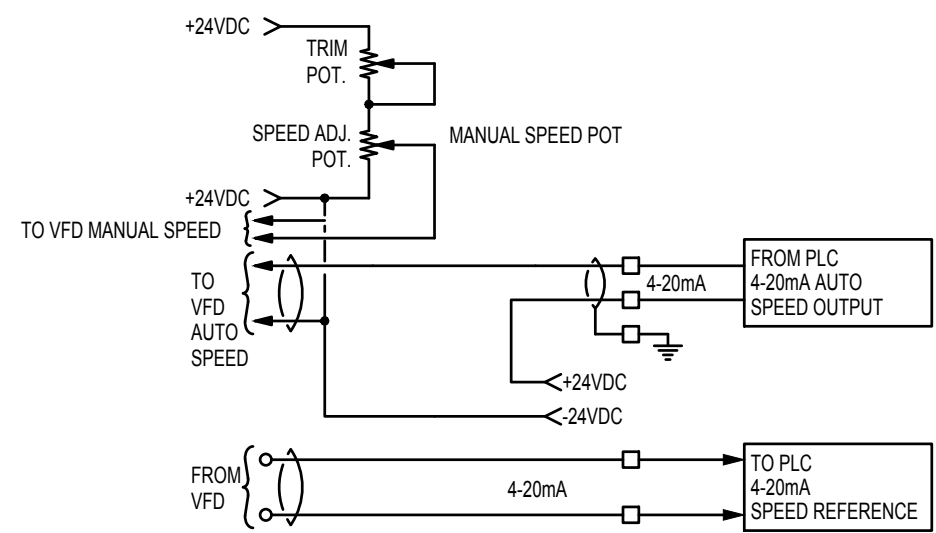

SIGNAL REPLICATION WITHIN PLC CABINET

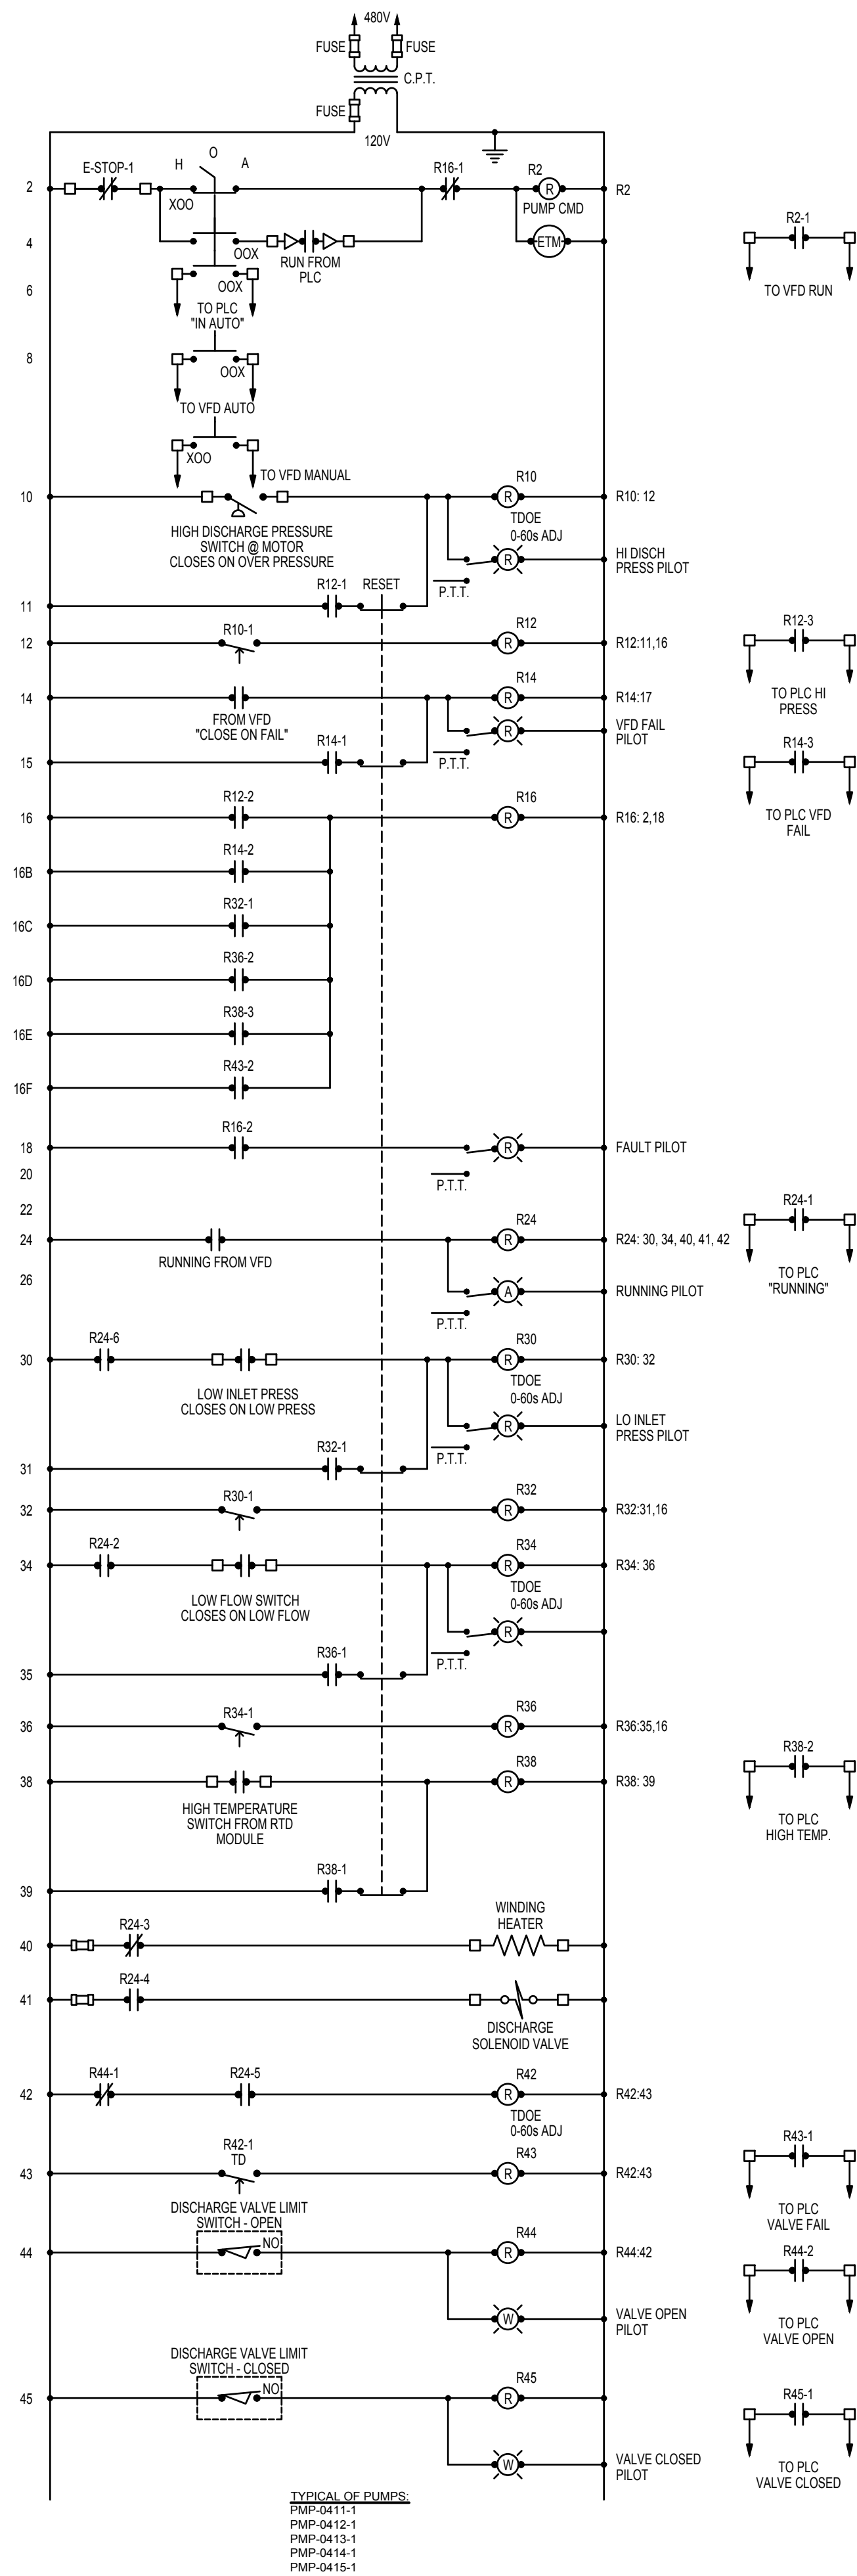

HIGH SERVICE PUMP VFD CONTROL DIAGRAM

VERIFY SCALE
BAR IS ONE INCH ON ORIGINAL DRAWING



PROJECT

PROVO RIVER
WATER TREATMENT
PLANT


CLIENT

PROVO CITY
PUBLIC WORKS
1377 South 350 East
Provo, UT 84606
Tel: (801) 852-6700



CONSULTANTS

AECOM
756 East Winchester Street
Salt Lake City, UT 84107
Tel: (801) 904-4000 Fax: (801) 904-4100
http:// www.aecom.com
Hansen, Allen & Luce, Inc.
859 West South Jordan Pkwy, Ste 200
South Jordan, UT 84095
Tel: (801) 566-6599
http:// www.hansenallenluce.com

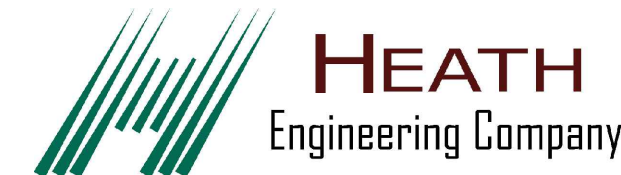

REGISTRATION



ISSUE/REVISION

B	2023-04-07	ISSUED FOR BID
A	2023-01-20	ISSUED FOR 90%
I/R	DATE	DESCRIPTION

PROJECT NUMBER

AECOM Project No. - 60670884
HAL Project No. - 035.15.420


SHEET TITLE

CLEARWELL AND
PUMP STATION
ELECTRICAL
TYPICAL CONTROL
DIAGRAM

DRAWING NUMBER

20-E603

VERIFY SCALE
BAR IS ONE INCH ON ORIGINAL DRAWING

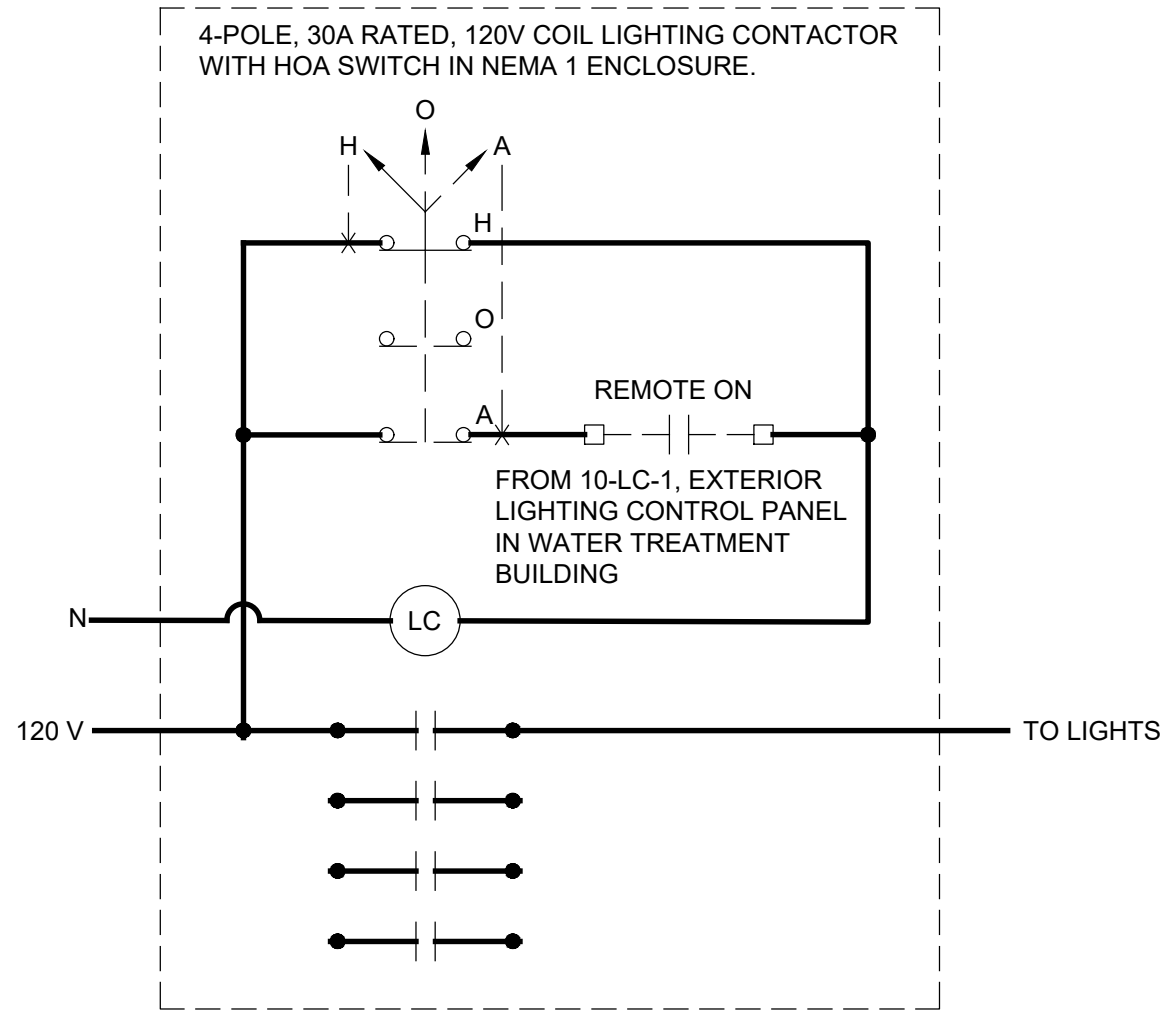

20-LX-1 - EXTERIOR LIGHTING CONTROL DIAGRAM
SCALE: NOT TO SCALE



PROJECT

PROVO RIVER
WATER TREATMENT
PLANT

CLIENT

PROVO CITY
PUBLIC WORKS
1377 South 350 East
Provo, UT 84606
Tel: (801) 852-6700



CONSULTANTS

AECOM
756 East Winchester Street
Salt Lake City, UT 84107
Tel: (801) 904-4000 Fax: (801) 904-4100
http:// www.aecom.com
Hansen, Allen & Luce, Inc.
859 West South Jordan Pkwy, Ste 200
South Jordan, UT 84095
Tel: (801) 586-5599
http:// www.hansenallenluce.com

REGISTRATION

ISSUE/REVISION

D	2023-04-07	ISSUED FOR BID
C	2023-01-20	ISSUED FOR 90%
B	2022-10-14	ISSUED FOR 60%
A	2022-07-01	ISSUED FOR 30%
I/R	DATE	DESCRIPTION

PROJECT NUMBER

AECOM Project No. - 60670884
HAL Project No. - 035.15.420

SHEET TITLE

CLEARWELL AND
PUMP STATION
ELECTRICAL
EXTERIOR LIGHTING
CONTROL DIAGRAM

DRAWING NUMBER

20-E604